
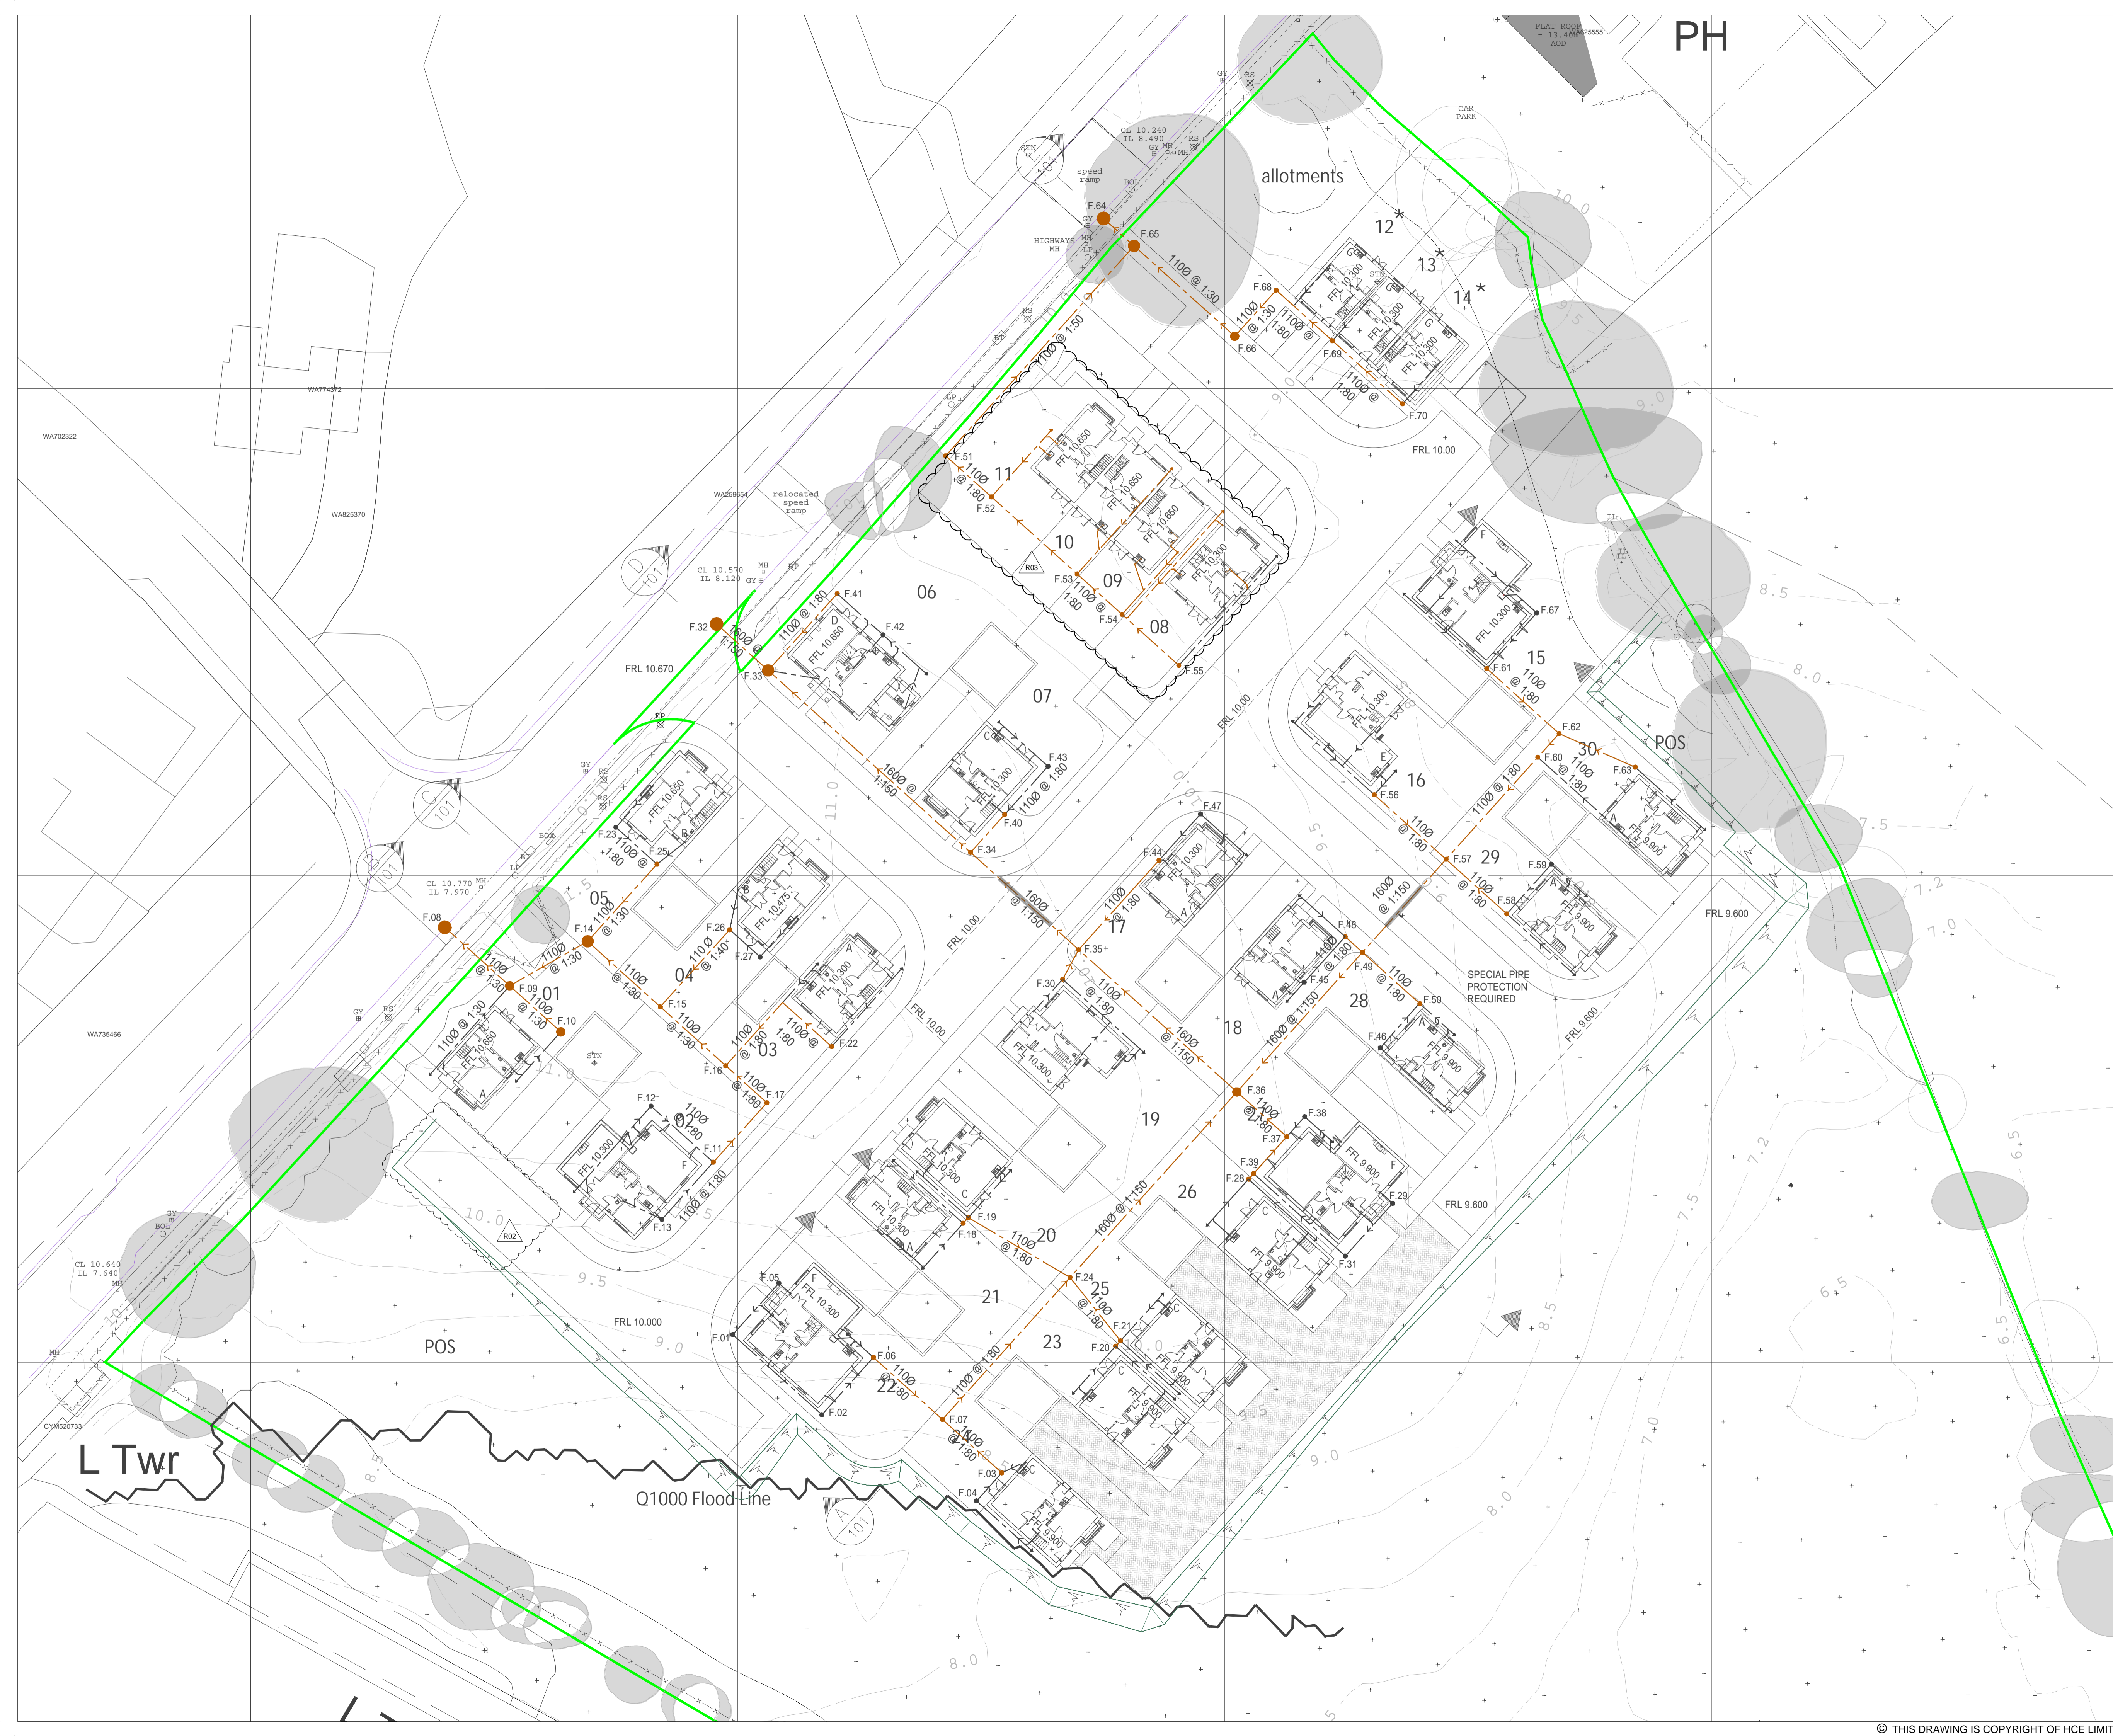


DO NOT SCALE

General

1. For all notes and specifications refer drawing No. 001.
2. For Sections refer to drawing No's 101 & 102.
3. For standard drainage details refer drawing No's 111 & 112

Key

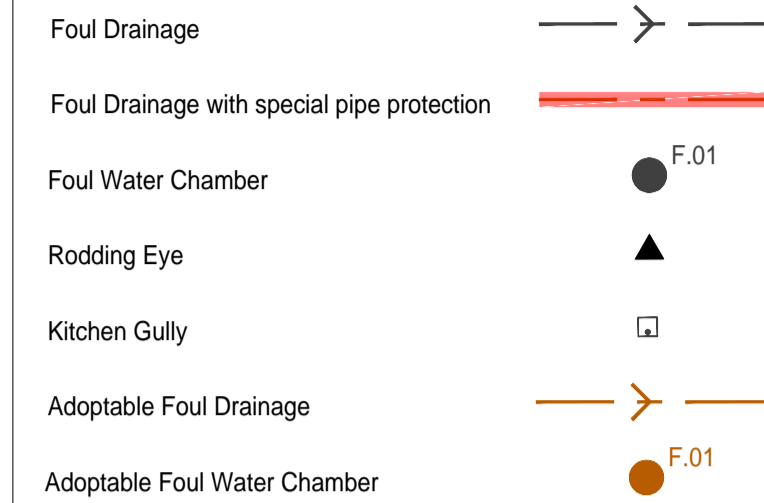

REV	DATE	BY	DESCRIPTION	CHK	APPD
R03	04.04.2022	AH	PLOTS 8-11 LAYOUT AMENDED	IH	IH
R02	09.06.2021	JA	AMENDED SITE LAYOUT	IH	IH
R01	23.03.2021	JA	INITIAL ISSUE	IH	IH

DRAWING STATUS: FOR INFORMATION

HCE

Civil Engineering
Structural Engineering
Structural Surveys
Project Management
Petrochemical

HCE Limited
Canolfan Gorselion Centre
Miliers Drive
Gorselion
SA4 4QN

Tel: 01792 805010
E-mail: info@hcelimited.com
Web: www.hcelimited.com

CLIENT: HAYWOOD HOMES

ARCHITECT: ZEBRA ARCHITECTS

PROJECT: RESIDENTIAL DEVELOPMENT GWAELOD Y MAES LLANGENNECH

TITLE: DCWW S104 DRAINAGE PLAN

SCALE @ A1: 1:300	CHECKED: IH	APPROVED: IH
CAD FILE: HCE-1386-111	DESIGN-DRAWN: JA	DATE: 23.03.2021

PROJECT No: 1386	DRAWING No: 111	REV: R03
------------------	-----------------	----------