
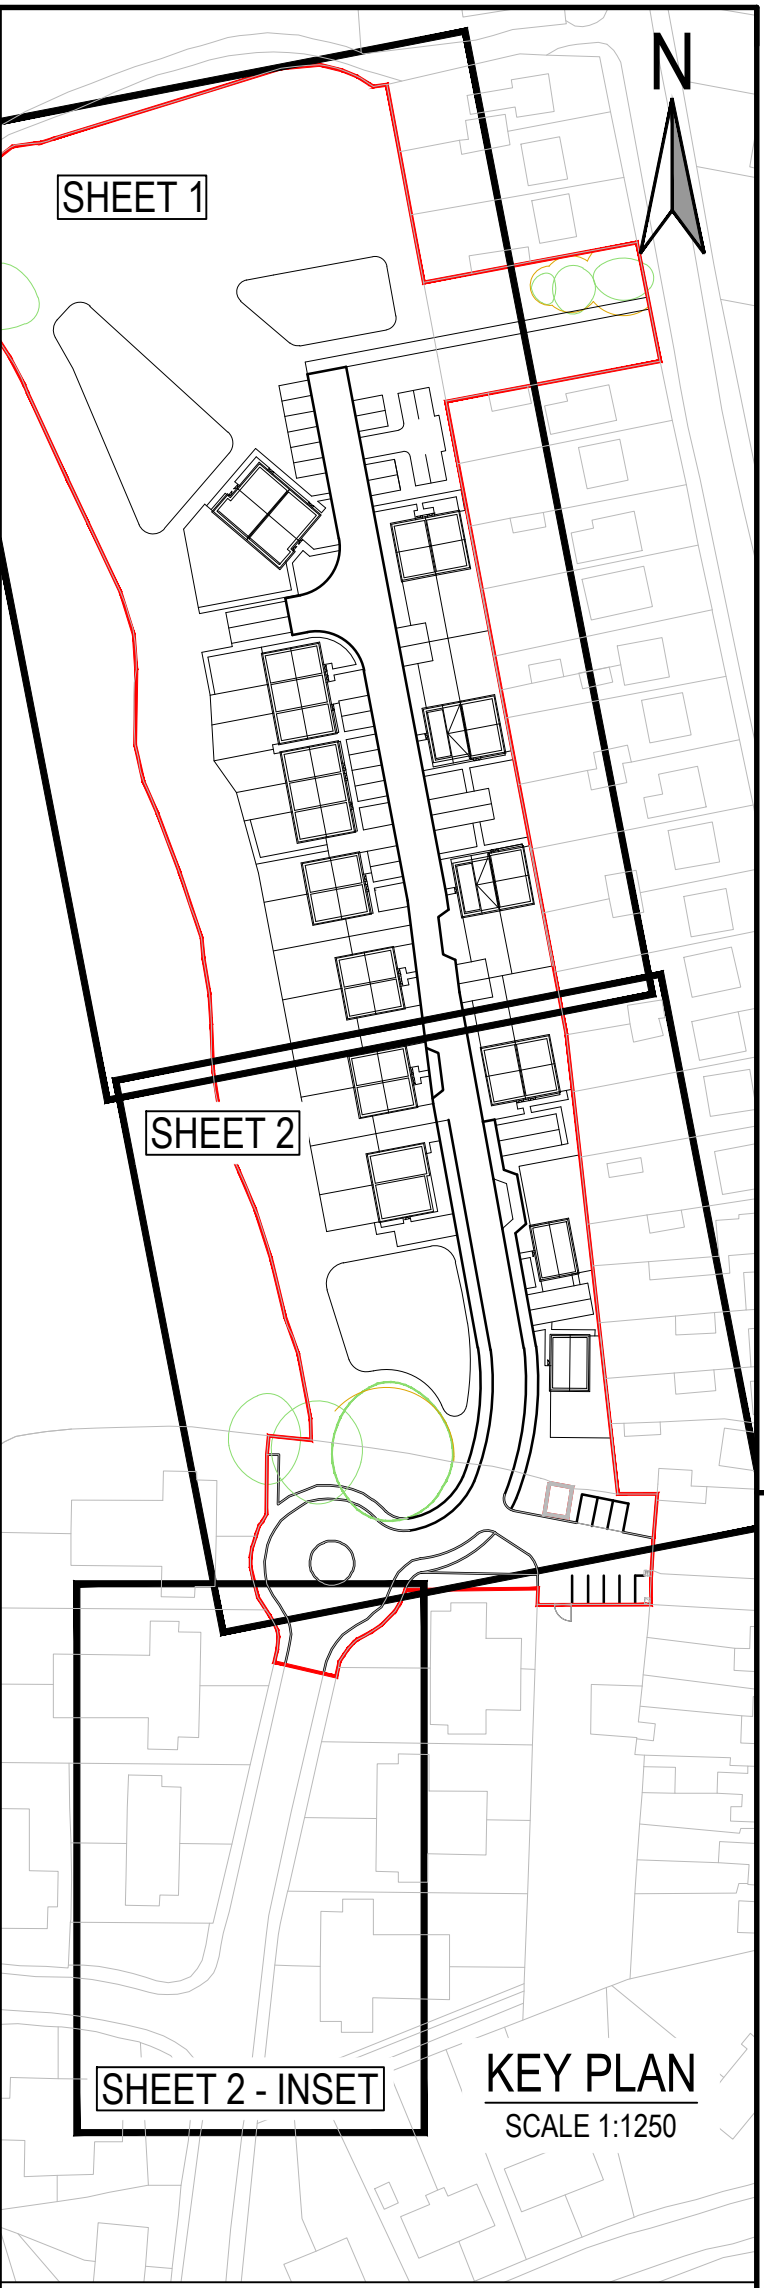


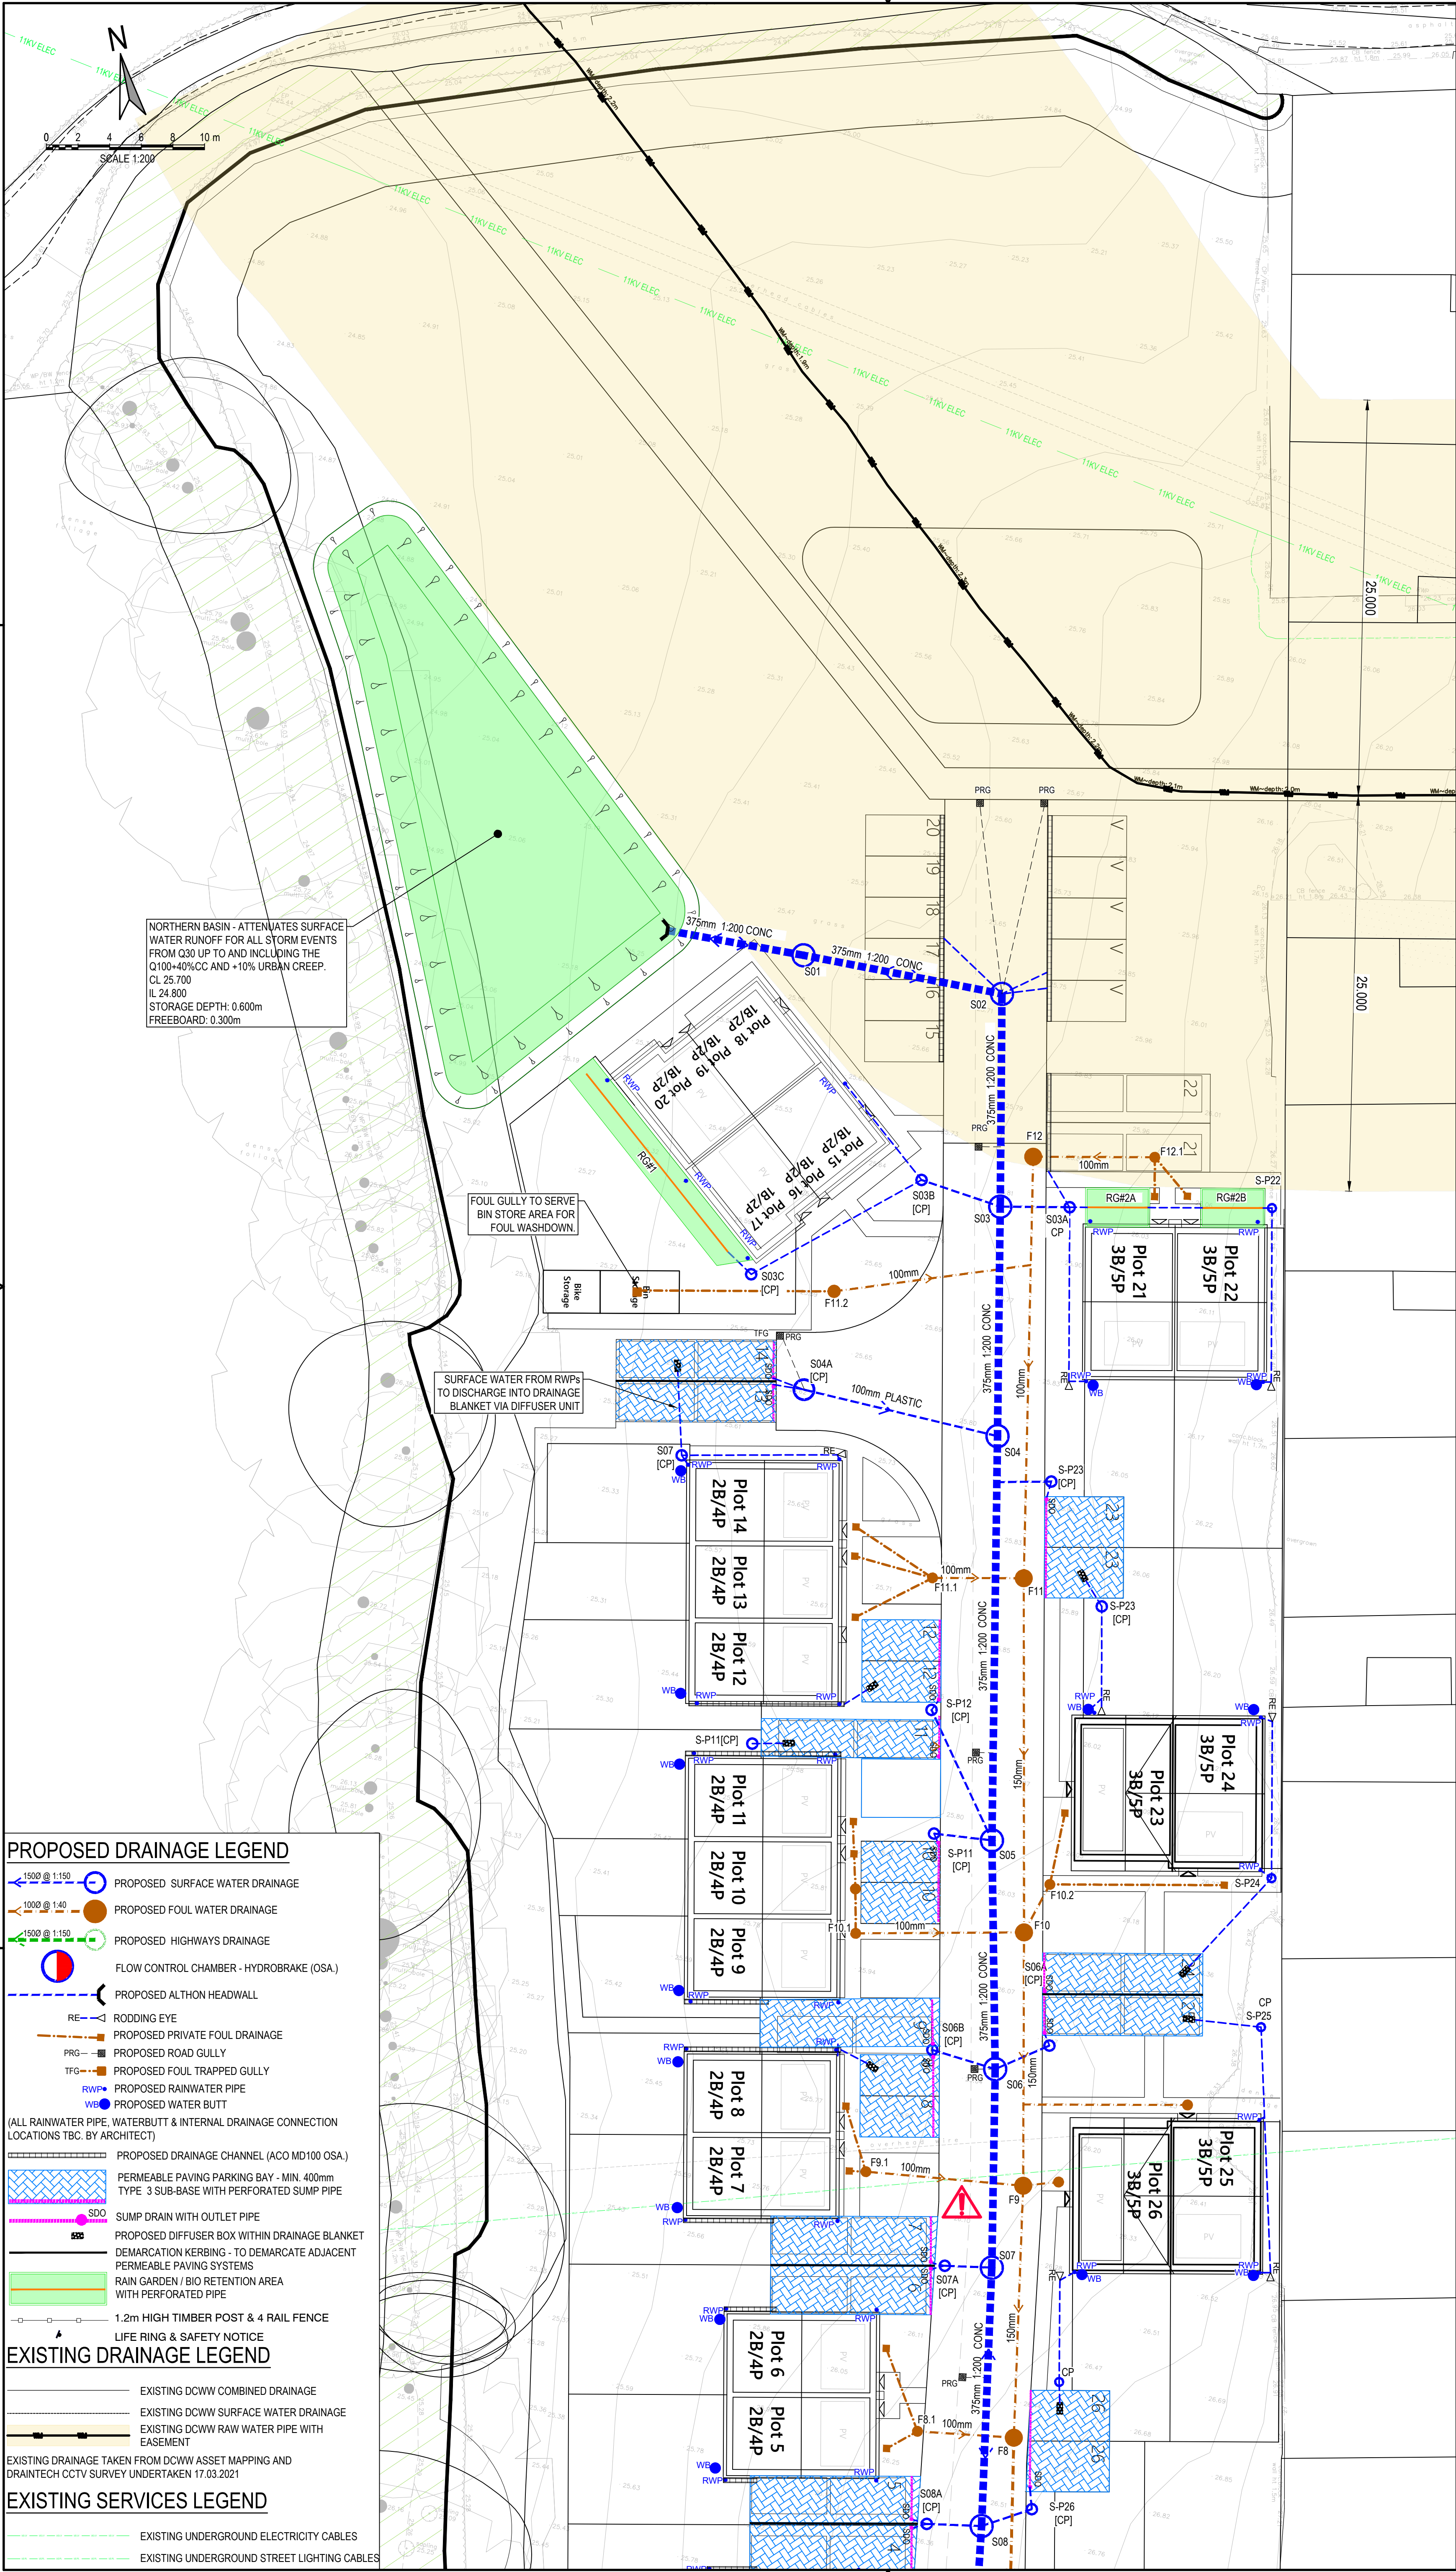

- NOTES:
- ALL DIMENSIONS ARE IN MILLIMETRES UNLESS NOTED OTHERWISE.
 - ALL LEVELS ARE SHOWN IN METRES UNLESS NOTED OTHERWISE.
 - DO NOT SCALE FROM THE DRAWING. USE FIGURED DIMENSIONS ONLY.
 - ANY DISCREPANCIES TO BE REPORTED IMMEDIATELY TO THE ENGINEER.
 - THIS DRAWING TO BE READ IN CONJUNCTION WITH ALL RELEVANT ARCHITECTS, ENGINEERS, SUBCONTRACTORS AND SPECIALISTS DRAWINGS AND SPECIFICATIONS.
 - EXISTING SERVICES HAVE NOT BEEN SHOWN BUT ARE PRESENT - THE CONTRACTOR IS TO LIAISE WITH ALL STATUTORY AUTHORITIES PRIOR TO THE COMMENCEMENT OF ANY WORKS.
- FOR DRAINAGE NOTES REFER TO DRG. 18649/500.

CAUTION: BEWARE OF UNDERGROUND SERVICES IN THE VICINITY. ALL EXCAVATIONS TO BE IN ACCORDANCE WITH HSG47

ANY WORKS ON SITE PRIOR TO PLANNING, HIGHWAY/ DRAINAGE APPROVALS BEING GRANTED TO BE UNDERTAKEN AT DEVELOPER / CONTRACTORS OWN RISK.

PRELIMINARY

03	HT	PG	-	UPDATED TO SUIT NEW SITE LAYOUT			
02	HT	PG	-	MINOR AMENDMENTS			
01	HT	PG	-	FIRST ISSUE			
rev.	drawn	chkd.	apprvd.	description			
		date					
Client							
DANTWYN (PONTARDDULAI) LTD							
Project							
GLYNHIR ROAD PONTARDDULAI SA4 8PT							
Title							
DRAINAGE LAYOUT SHEET 1							
 ValeConsultancy CONSULTING CIVIL & STRUCTURAL ENGINEERS 29 Bocam Park, Old Field Road, Pencoeed, Bridgend CF35 5LJ. Phone: 01656 863794 Email: enquiries@vale-consultancy.co.uk							
date		drawn		checked		approved	
11.06.24		RM		PG			
scale @ A1				project no.			
1:200				18649			
status		drg. no.				rev.	
P		18649/501				03	