
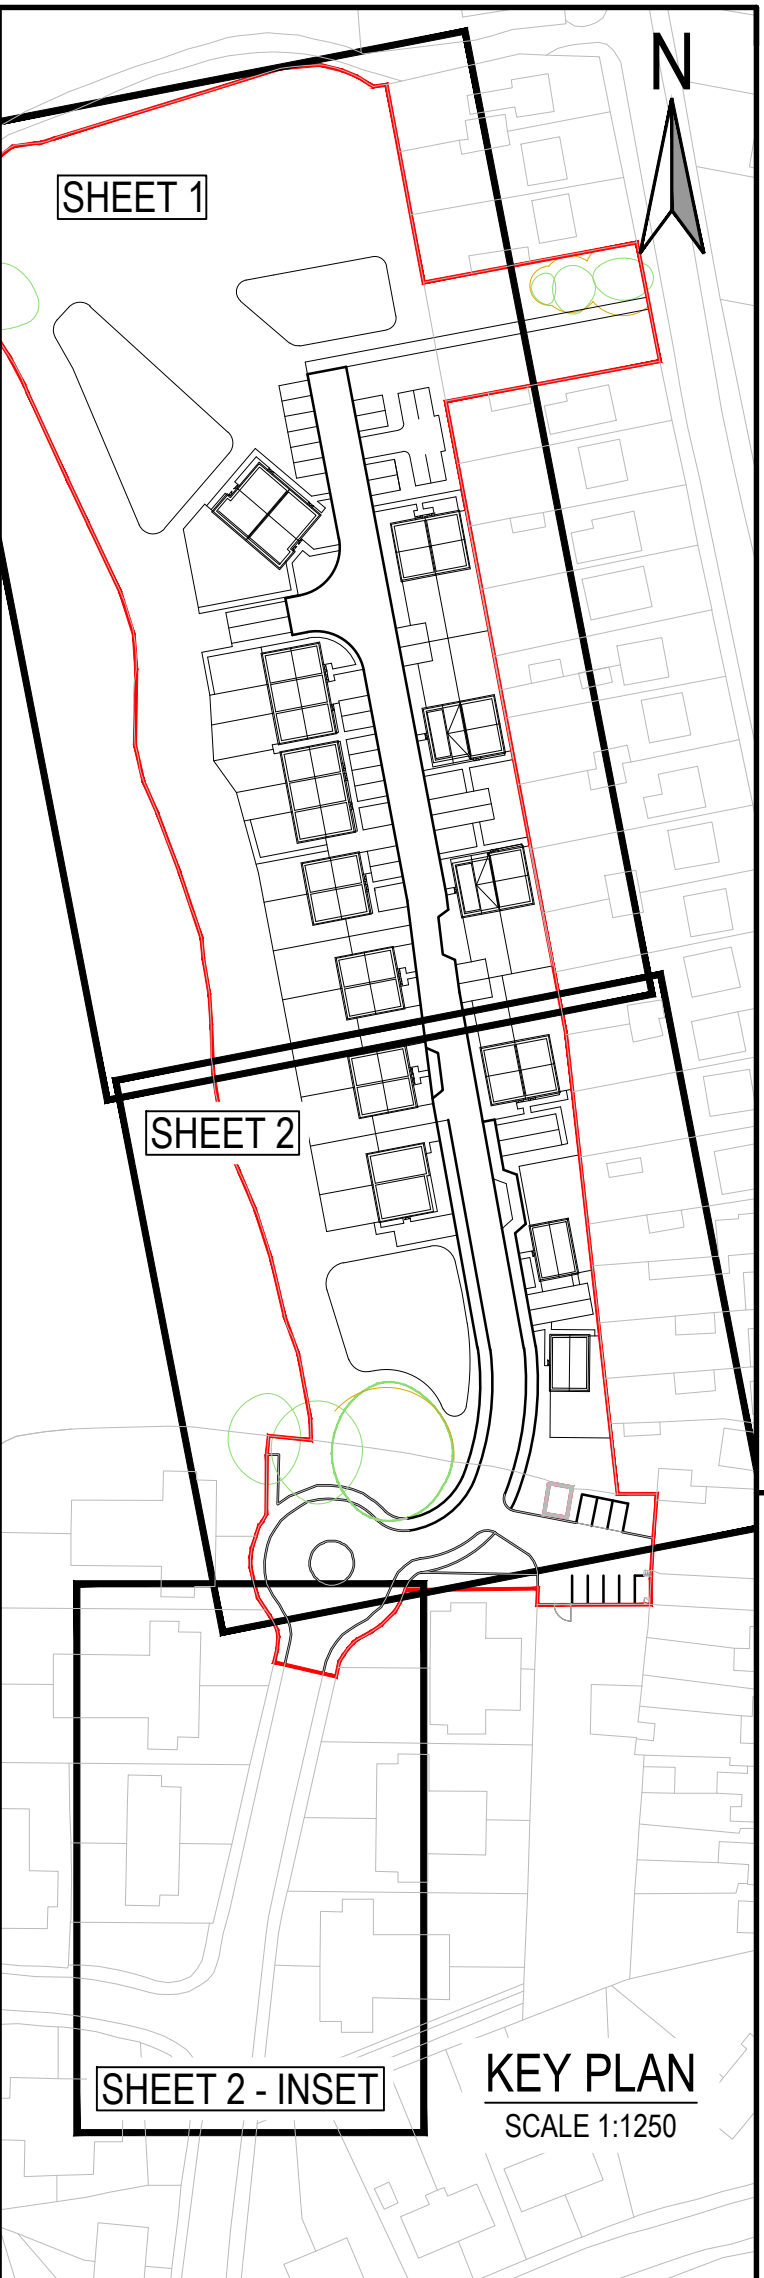


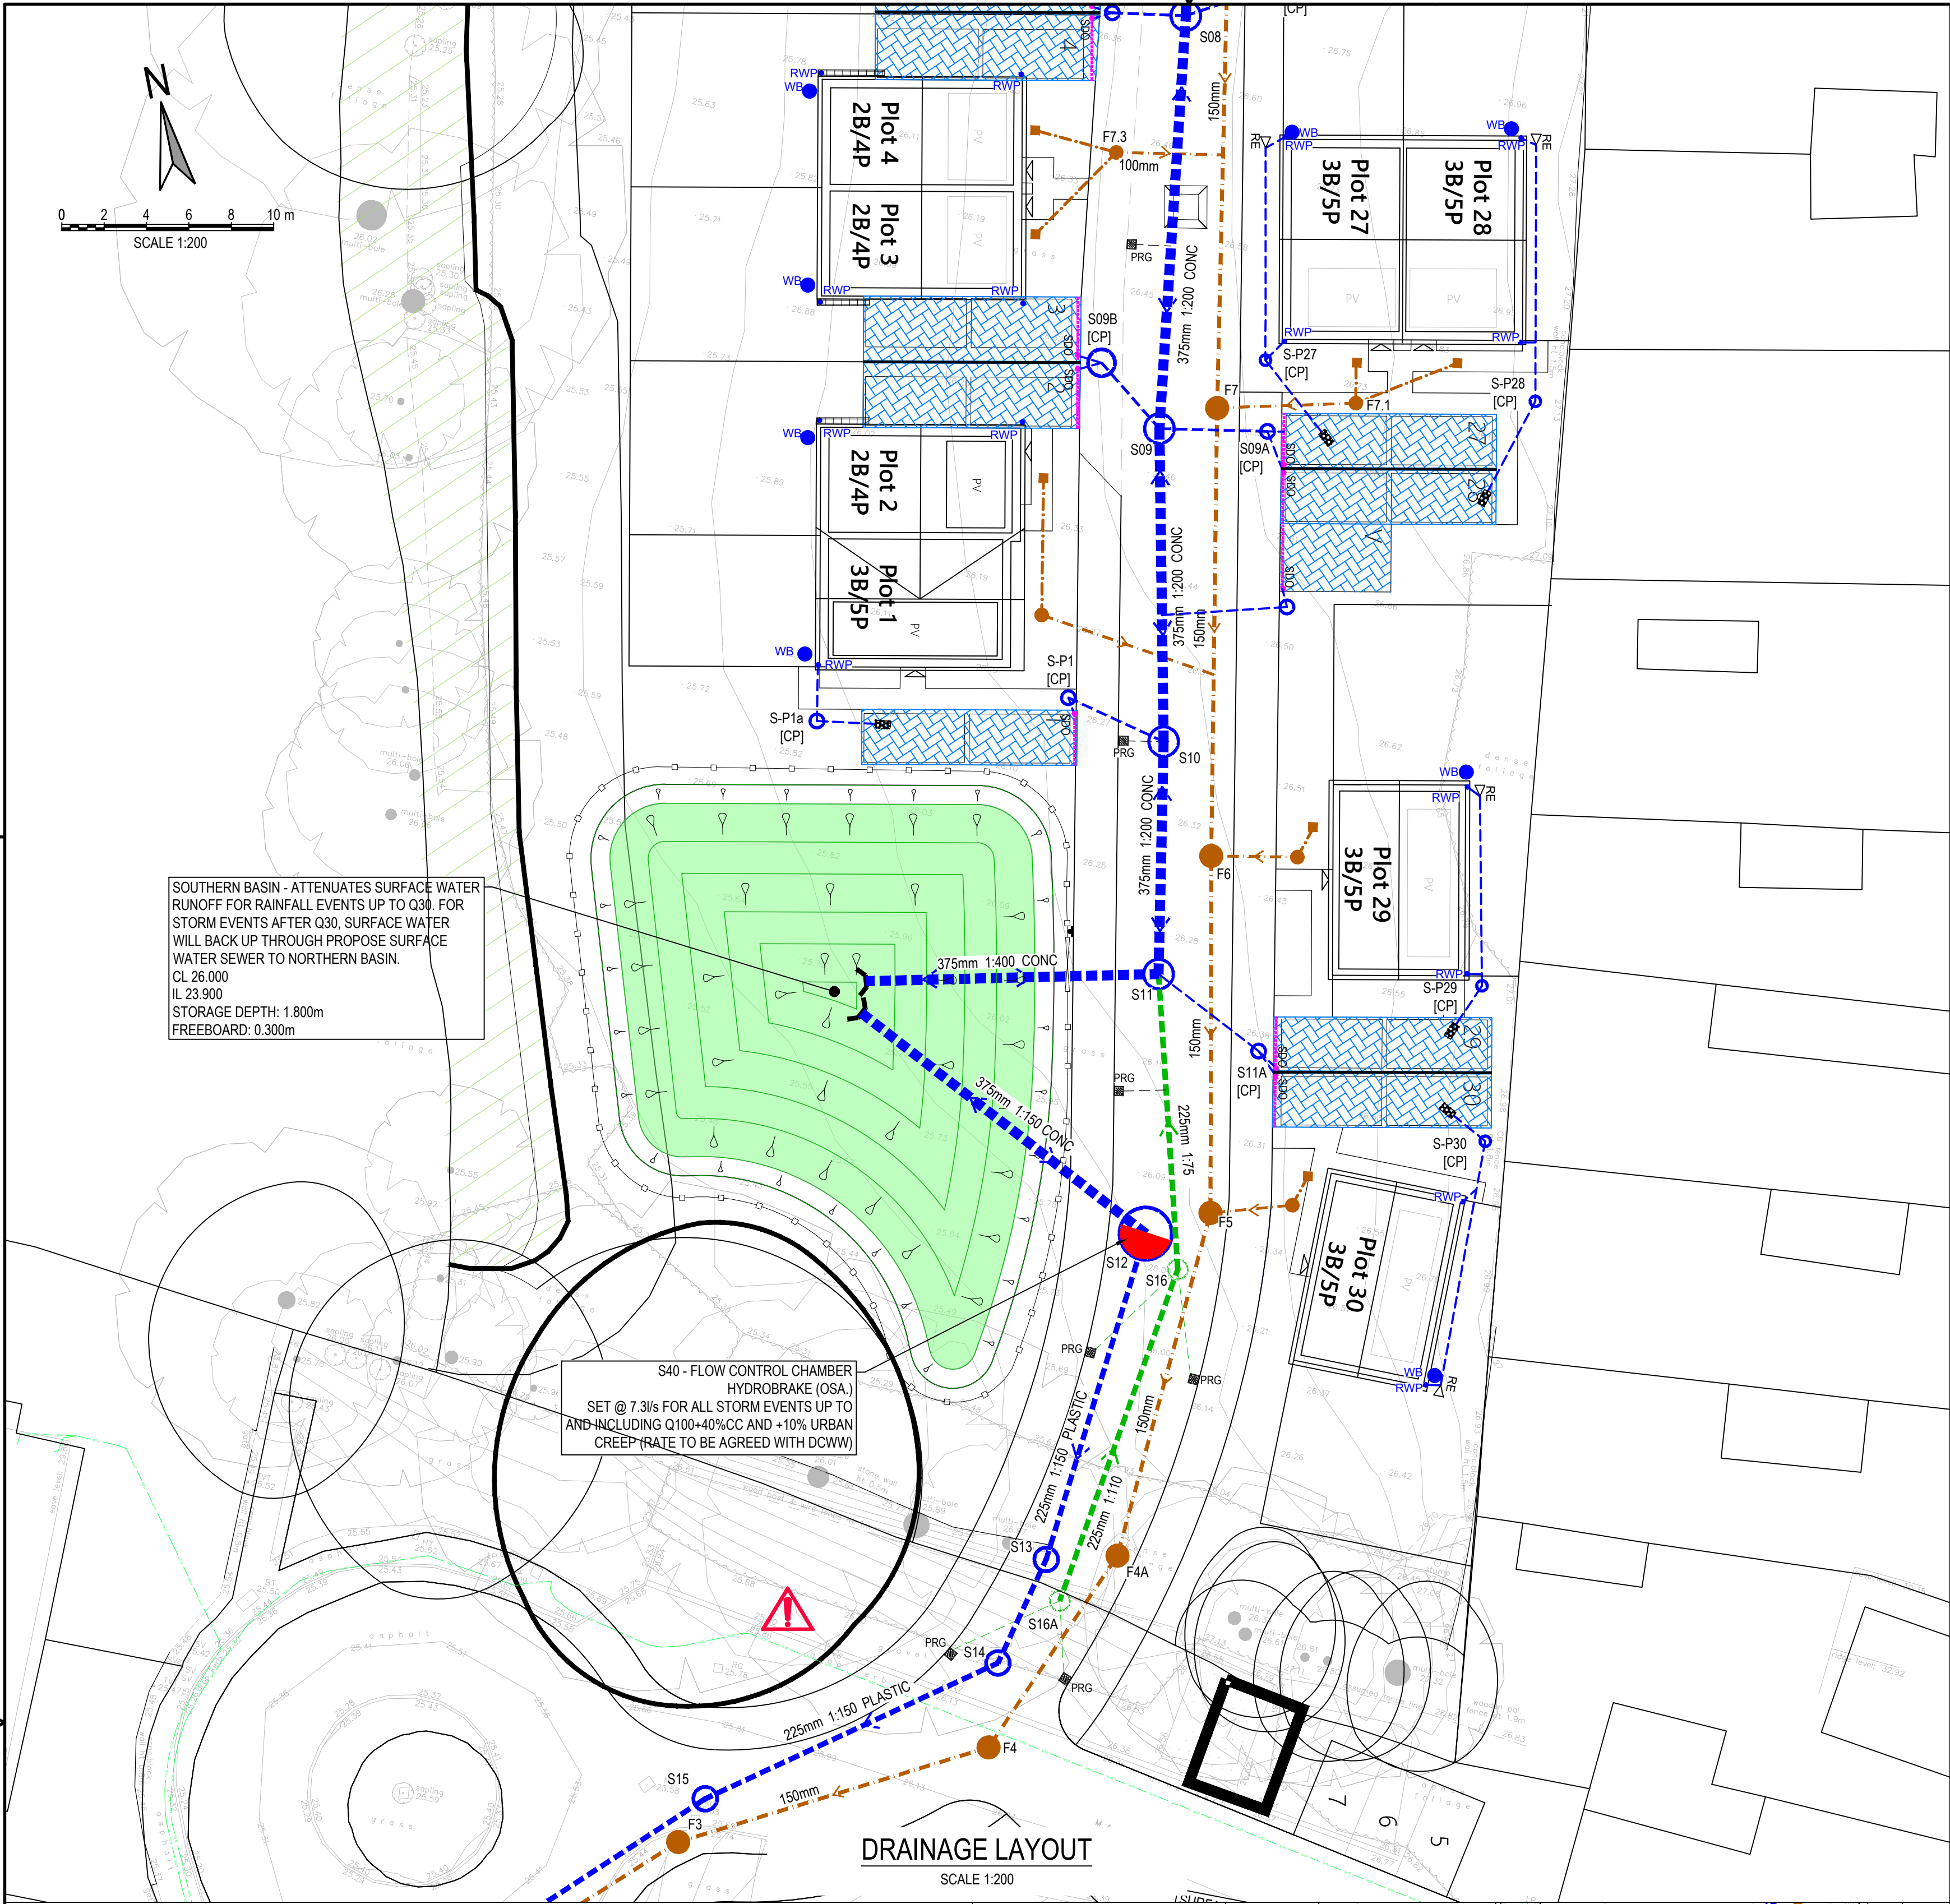

- NOTES:
- ALL DIMENSIONS ARE IN MILLIMETRES UNLESS NOTED OTHERWISE.
 - ALL LEVELS ARE SHOWN IN METRES UNLESS NOTED OTHERWISE.
 - DO NOT SCALE FROM THE DRAWING. USE FIGURED DIMENSIONS ONLY.
 - ANY DISCREPANCIES TO BE REPORTED IMMEDIATELY TO THE ENGINEER.
 - THIS DRAWING TO BE READ IN CONJUNCTION WITH ALL RELEVANT ARCHITECTS, ENGINEERS, SUBCONTRACTORS AND SPECIALISTS DRAWINGS AND SPECIFICATIONS.
 - EXISTING SERVICES HAVE NOT BEEN SHOWN BUT ARE PRESENT - THE CONTRACTOR IS TO LIAISE WITH ALL STATUTORY AUTHORITIES PRIOR TO THE COMMENCEMENT OF ANY WORKS.
- FOR DRAINAGE NOTES REFER TO DRG. 18649/500.

CAUTION: BEWARE OF UNDERGROUND SERVICES IN THE VICINITY. ALL EXCAVATIONS TO BE IN ACCORDANCE WITH HSG47

ANY WORKS ON SITE PRIOR TO PLANNING, HIGHWAY/ DRAINAGE APPROVALS BEING GRANTED TO BE UNDERTAKEN AT DEVELOPER / CONTRACTORS OWN RISK.

PROPOSED DRAINAGE LEGEND

- 1500 @ 1:150 PROPOSED SURFACE WATER DRAINAGE
- 1000 @ 1:40 PROPOSED FOUL WATER DRAINAGE
- 1500 @ 1:150 PROPOSED HIGHWAYS DRAINAGE
- FLOW CONTROL CHAMBER - HYDROBRAKE (OSA)
- PROPOSED ALTHON HEADWALL
- RE - RODDING EYE
- PROPOSED PRIVATE FOUL DRAINAGE
- PRG - PROPOSED ROAD GULLY
- TFG - PROPOSED FOUL TRAPPED GULLY
- RWP - PROPOSED RAINWATER PIPE
- WB - PROPOSED WATER BUTT
- (ALL RAINWATER PIPE, WATERBUTT & INTERNAL DRAINAGE CONNECTION LOCATIONS TBC. BY ARCHITECT)
- PROPOSED DRAINAGE CHANNEL (ACO MD100 USA)
- PERMEABLE PAVING PARKING BAY - MIN. 400mm TYPE 3 SUB-BASE WITH PERFORATED SUMP PIPE
- SDO - SUMP DRAIN WITH OUTLET PIPE
- PROPOSED DIFFUSER BOX WITHIN DRAINAGE BLANKET
- DEMARCATIION KERBING - TO DEMARCATIION ADJACENT PERMEABLE PAVING SYSTEMS
- RAIN GARDEN / BIO RETENTION AREA WITH PERFORATED PIPE
- 1.2m HIGH TIMBER POST & 4 RAIL FENCE
- LIFE RING & SAFETY NOTICE


EXISTING DRAINAGE LEGEND

- EXISTING DCWW COMBINED DRAINAGE
- EXISTING DCWW SURFACE WATER DRAINAGE
- EXISTING DCWW RAW WATER PIPE WITH EASEMENT

EXISTING DRAINAGE TAKEN FROM DCWW ASSET MAPPING AND DRAINECH CCTV SURVEY UNDERTAKEN 17.03.2021

EXISTING SERVICES LEGEND

- EXISTING UNDERGROUND ELECTRICITY CABLES
- EXISTING UNDERGROUND STREET LIGHTING CABLES

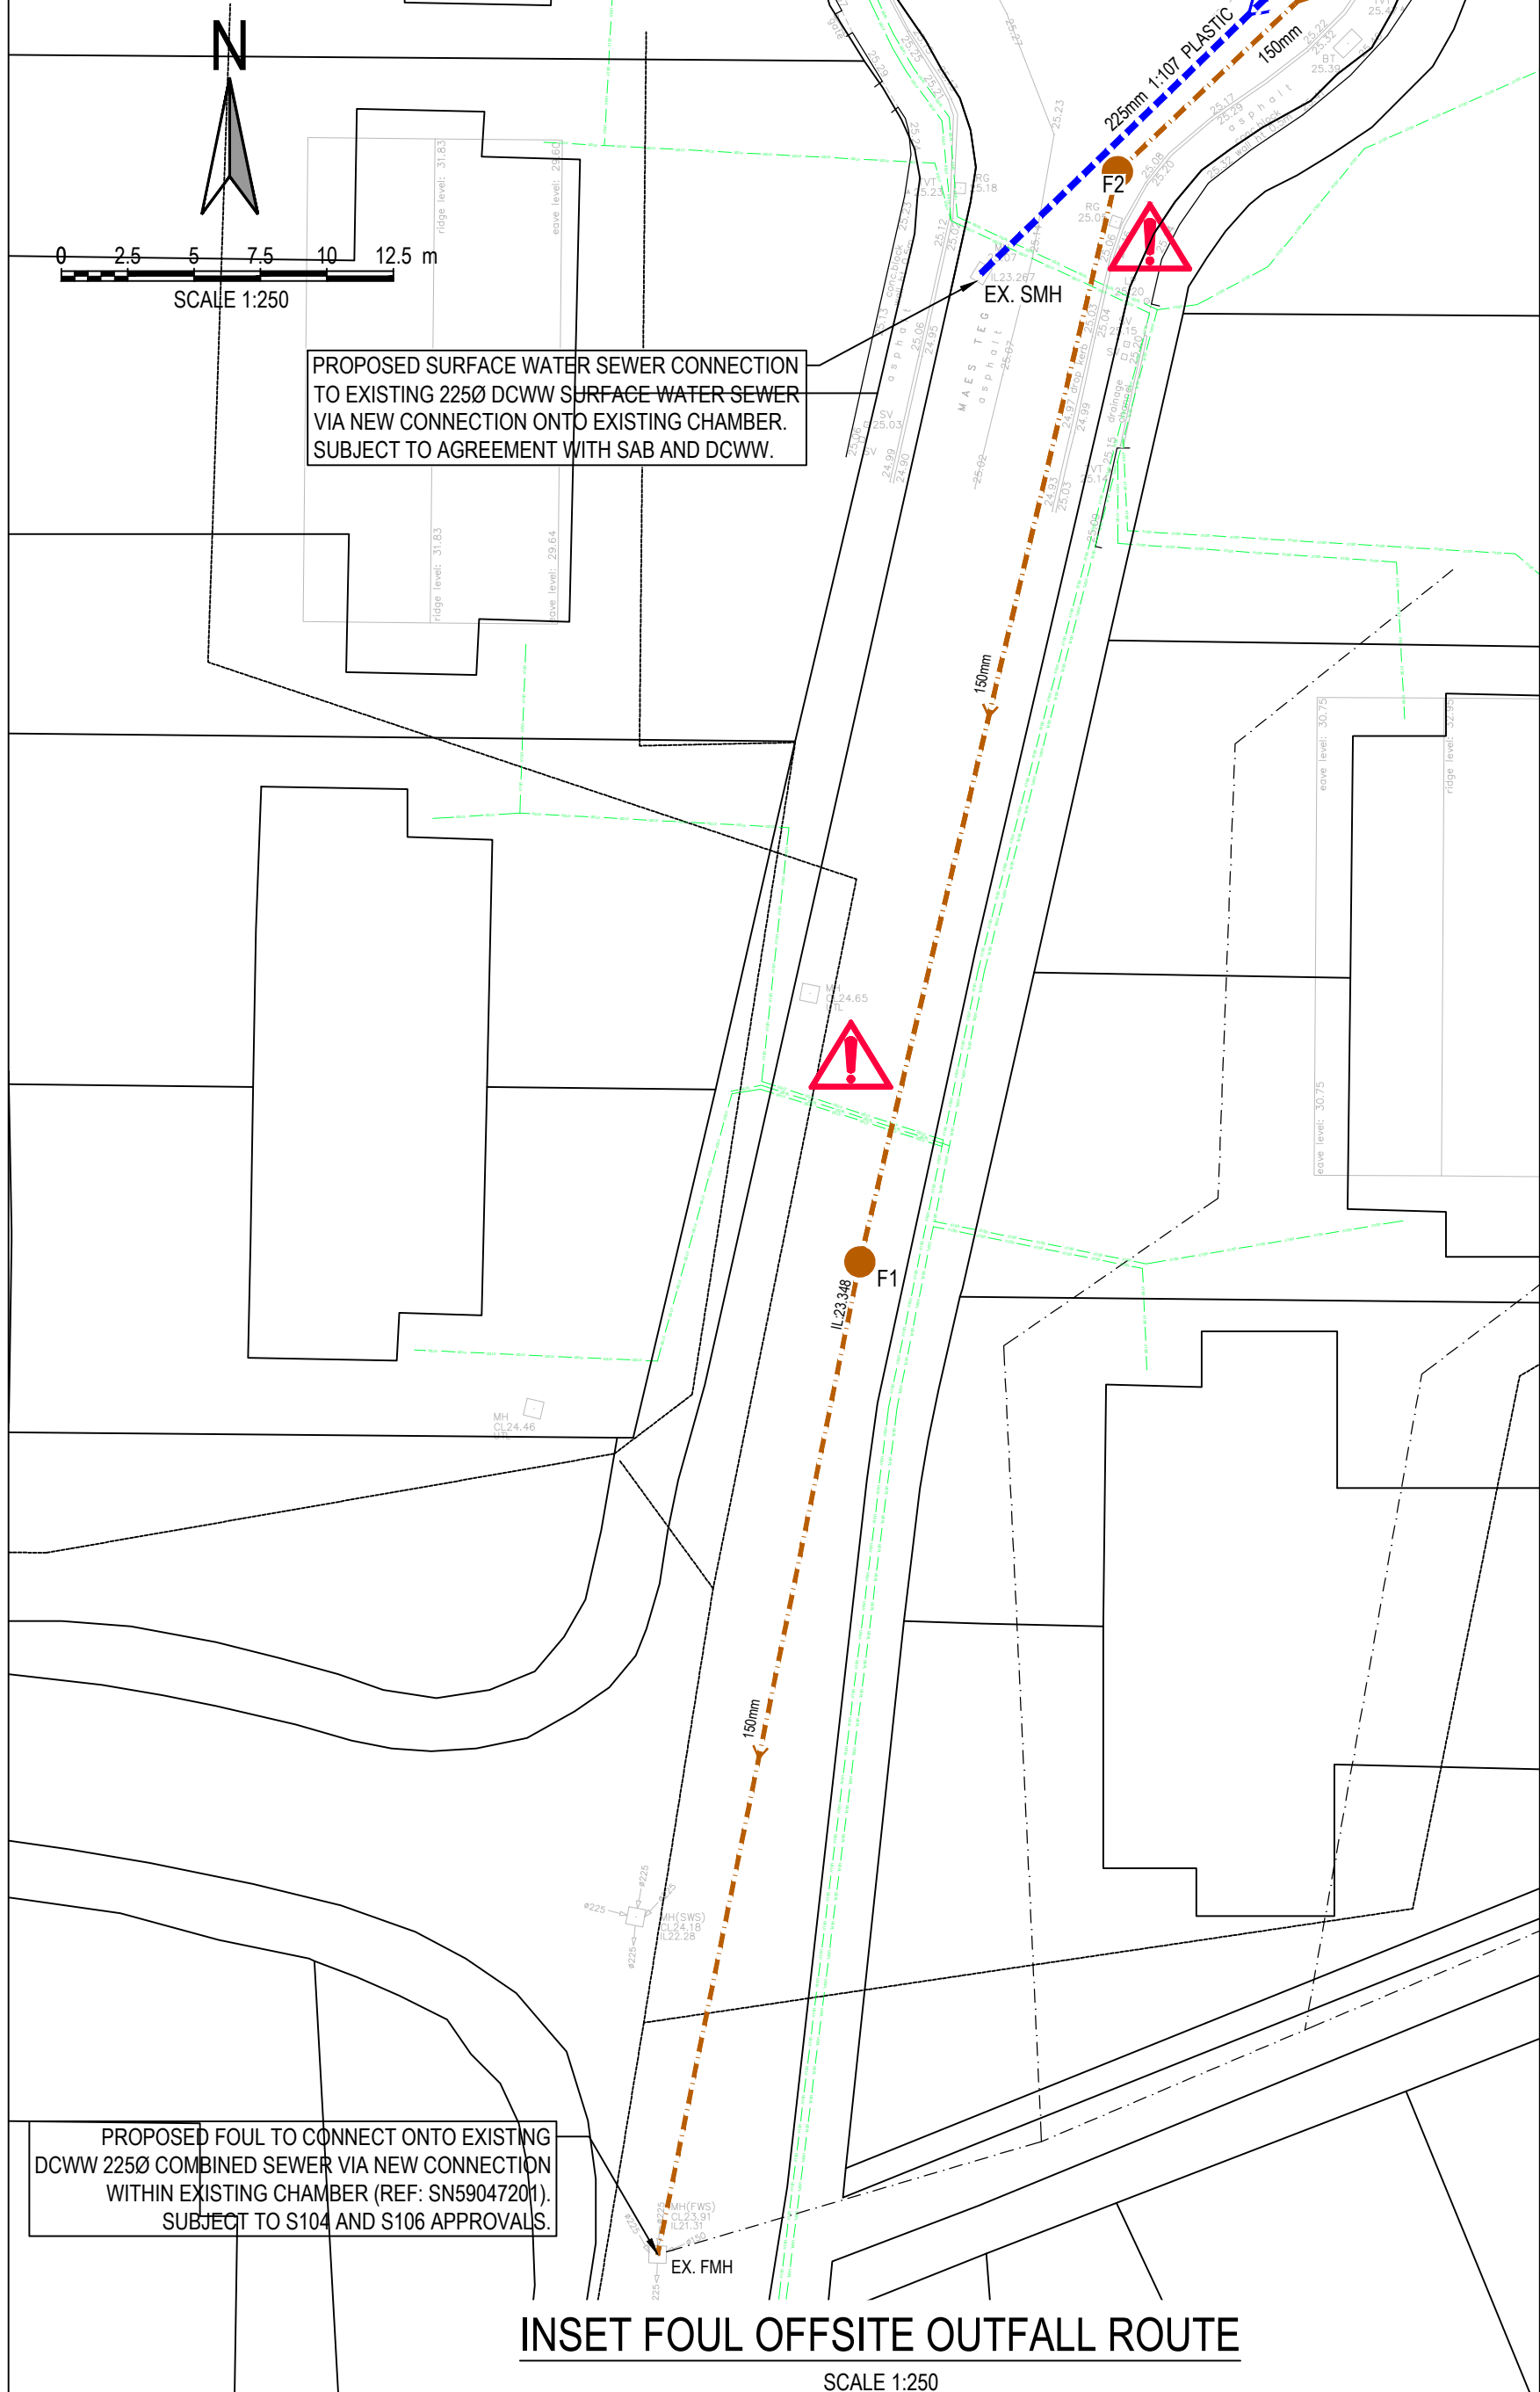

PRELIMINARY

03	HT	PG	-	UPDATED TO SUIT NEW SITE LAYOUT
02	HT	PG	-	MINOR AMENDMENTS
01	HT	PG	-	FIRST ISSUE
rev.	drawn	checked	approved	description
	CHW			
	date			
Client				
DANTWYN (PONTARDDULAI) LTD				
Project				
GLYNHIR ROAD PONTARDDULAI SA4 8PT				
Title				
DRAINAGE LAYOUT SHEET 2				
date				
11.06.24	drawn	checked	approved	
	RM	PG		
scale @ A1		project no.		
1:200 1:250		18649		
status		drg. no.		rev.
P		18649/502		03