



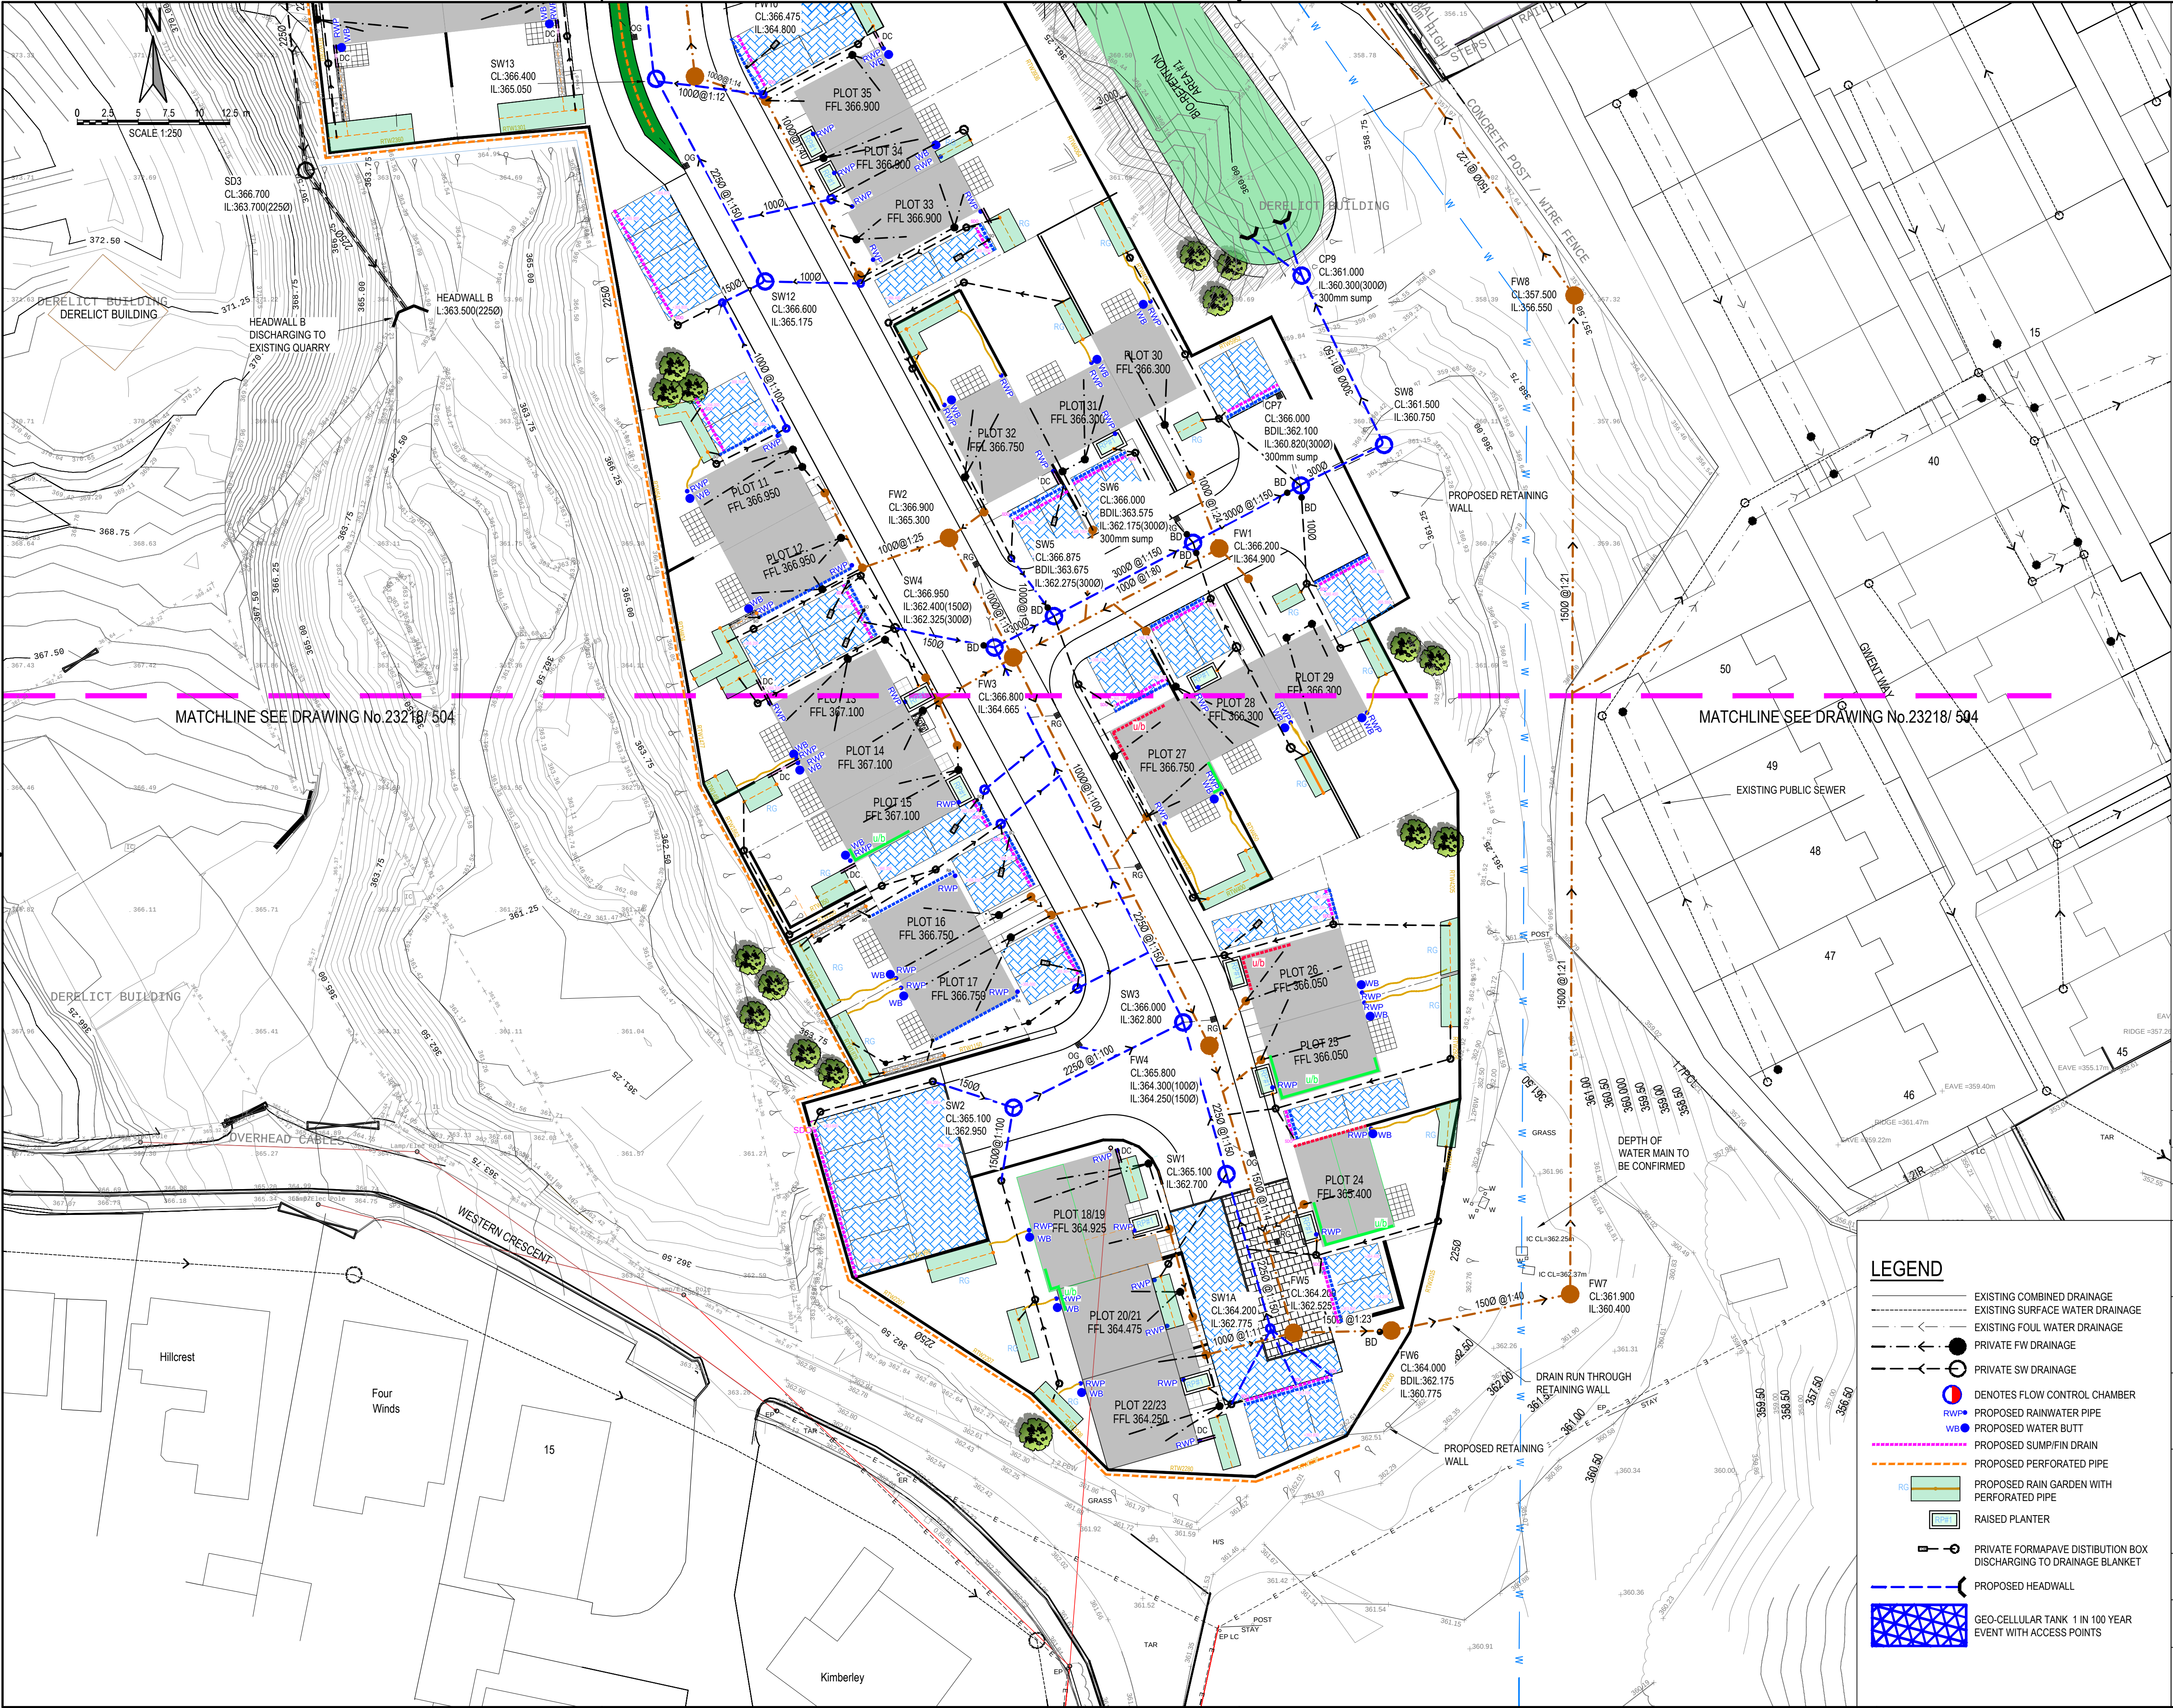

- NOTES:
1. ALL DIMENSIONS ARE IN MILLIMETRES UNLESS NOTED OTHERWISE.
 2. ALL LEVELS ARE SHOWN IN METRES UNLESS NOTED OTHERWISE.
 3. DO NOT SCALE FROM THE DRAWING. USE FIGURED DIMENSIONS ONLY.
 4. ANY DISCREPANCIES TO BE REPORTED IMMEDIATELY TO THE ENGINEER.
 5. THIS DRAWING TO BE READ IN CONJUNCTION WITH ALL RELEVANT ARCHITECTS, ENGINEERS, SUBCONTRACTORS AND SPECIALISTS DRAWINGS AND SPECIFICATIONS.
 6. EXISTING SERVICES HAVE NOT BEEN SHOWN BUT ARE PRESENT - THE CONTRACTOR IS TO LIAISE WITH ALL STATUTORY AUTHORITIES PRIOR TO THE COMMENCEMENT OF ANY WORKS.
 7. VALE CONSULTANCY ACCEPT NO LIABILITY FOR THE ACCURACY OR LOCATIONS OF SERVICES BASED ON THIRD-PARTY INFORMATION.
 8. THE CONTRACTOR IS TO LIAISE WITH ALL STATUTORY AUTHORITIES PRIOR TO THE COMMENCEMENT OF ANY WORKS - EXISTING SERVICES NOT LIMITED TO THIS PLAN
 9. DRAINAGE NOTES ARE ON DRG 23218_501.

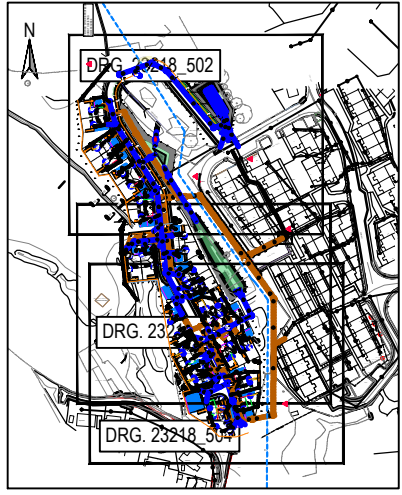

KEYPLAN

rev.	drawn	chd.	appd.	date	description
03	RGP	NRC	MJ	02.02.26	SERVICE STRIP ADDED TO REVISED PERMEABLE PAVING - PLOT NUMBERS AMENDED
02	RGP	NRC	MJ	02.02.26	PRELIMINARY
01	RGP	NRC	MJ	17.02.26	PRELIMINARY

Client
ADEPT CONSULTANTS

Project
TWN GLAS,
TREDEGAR, BLAENAU GWENT,
NP22 3EP

Title
SCHEME DRAINAGE LAYOUT
SHEET 3



29 Bocam Park, Old Field Road, Pencoed, Bridgend CF35 5LJ.
Phone: 01556 863794 Email: enquiries@vale-consultancy.co.uk

date	drawn	checked	approved
02.02.26	RGP	NRC	MJ

scale @	project no.
A1 1:250	23218

status	dir. no.	rev.
P	23218_504	03

LEGEND

- EXISTING COMBINED DRAINAGE
- EXISTING SURFACE WATER DRAINAGE
- EXISTING FOUL WATER DRAINAGE
- PRIVATE FW DRAINAGE
- PRIVATE SW DRAINAGE
- DENOTES FLOW CONTROL CHAMBER
- PROPOSED RAINWATER PIPE
- PROPOSED WATER BUTT
- PROPOSED SUMP/FIN DRAIN
- PROPOSED PERFORATED PIPE
- PROPOSED RAIN GARDEN WITH PERFORATED PIPE
- RAISED PLANTER
- PRIVATE FORMAPAVE DISTRIBUTION BOX DISCHARGING TO DRAINAGE BLANKET
- PROPOSED HEADWALL
- GEO-CELLULAR TANK 1 IN 100 YEAR EVENT WITH ACCESS POINTS