


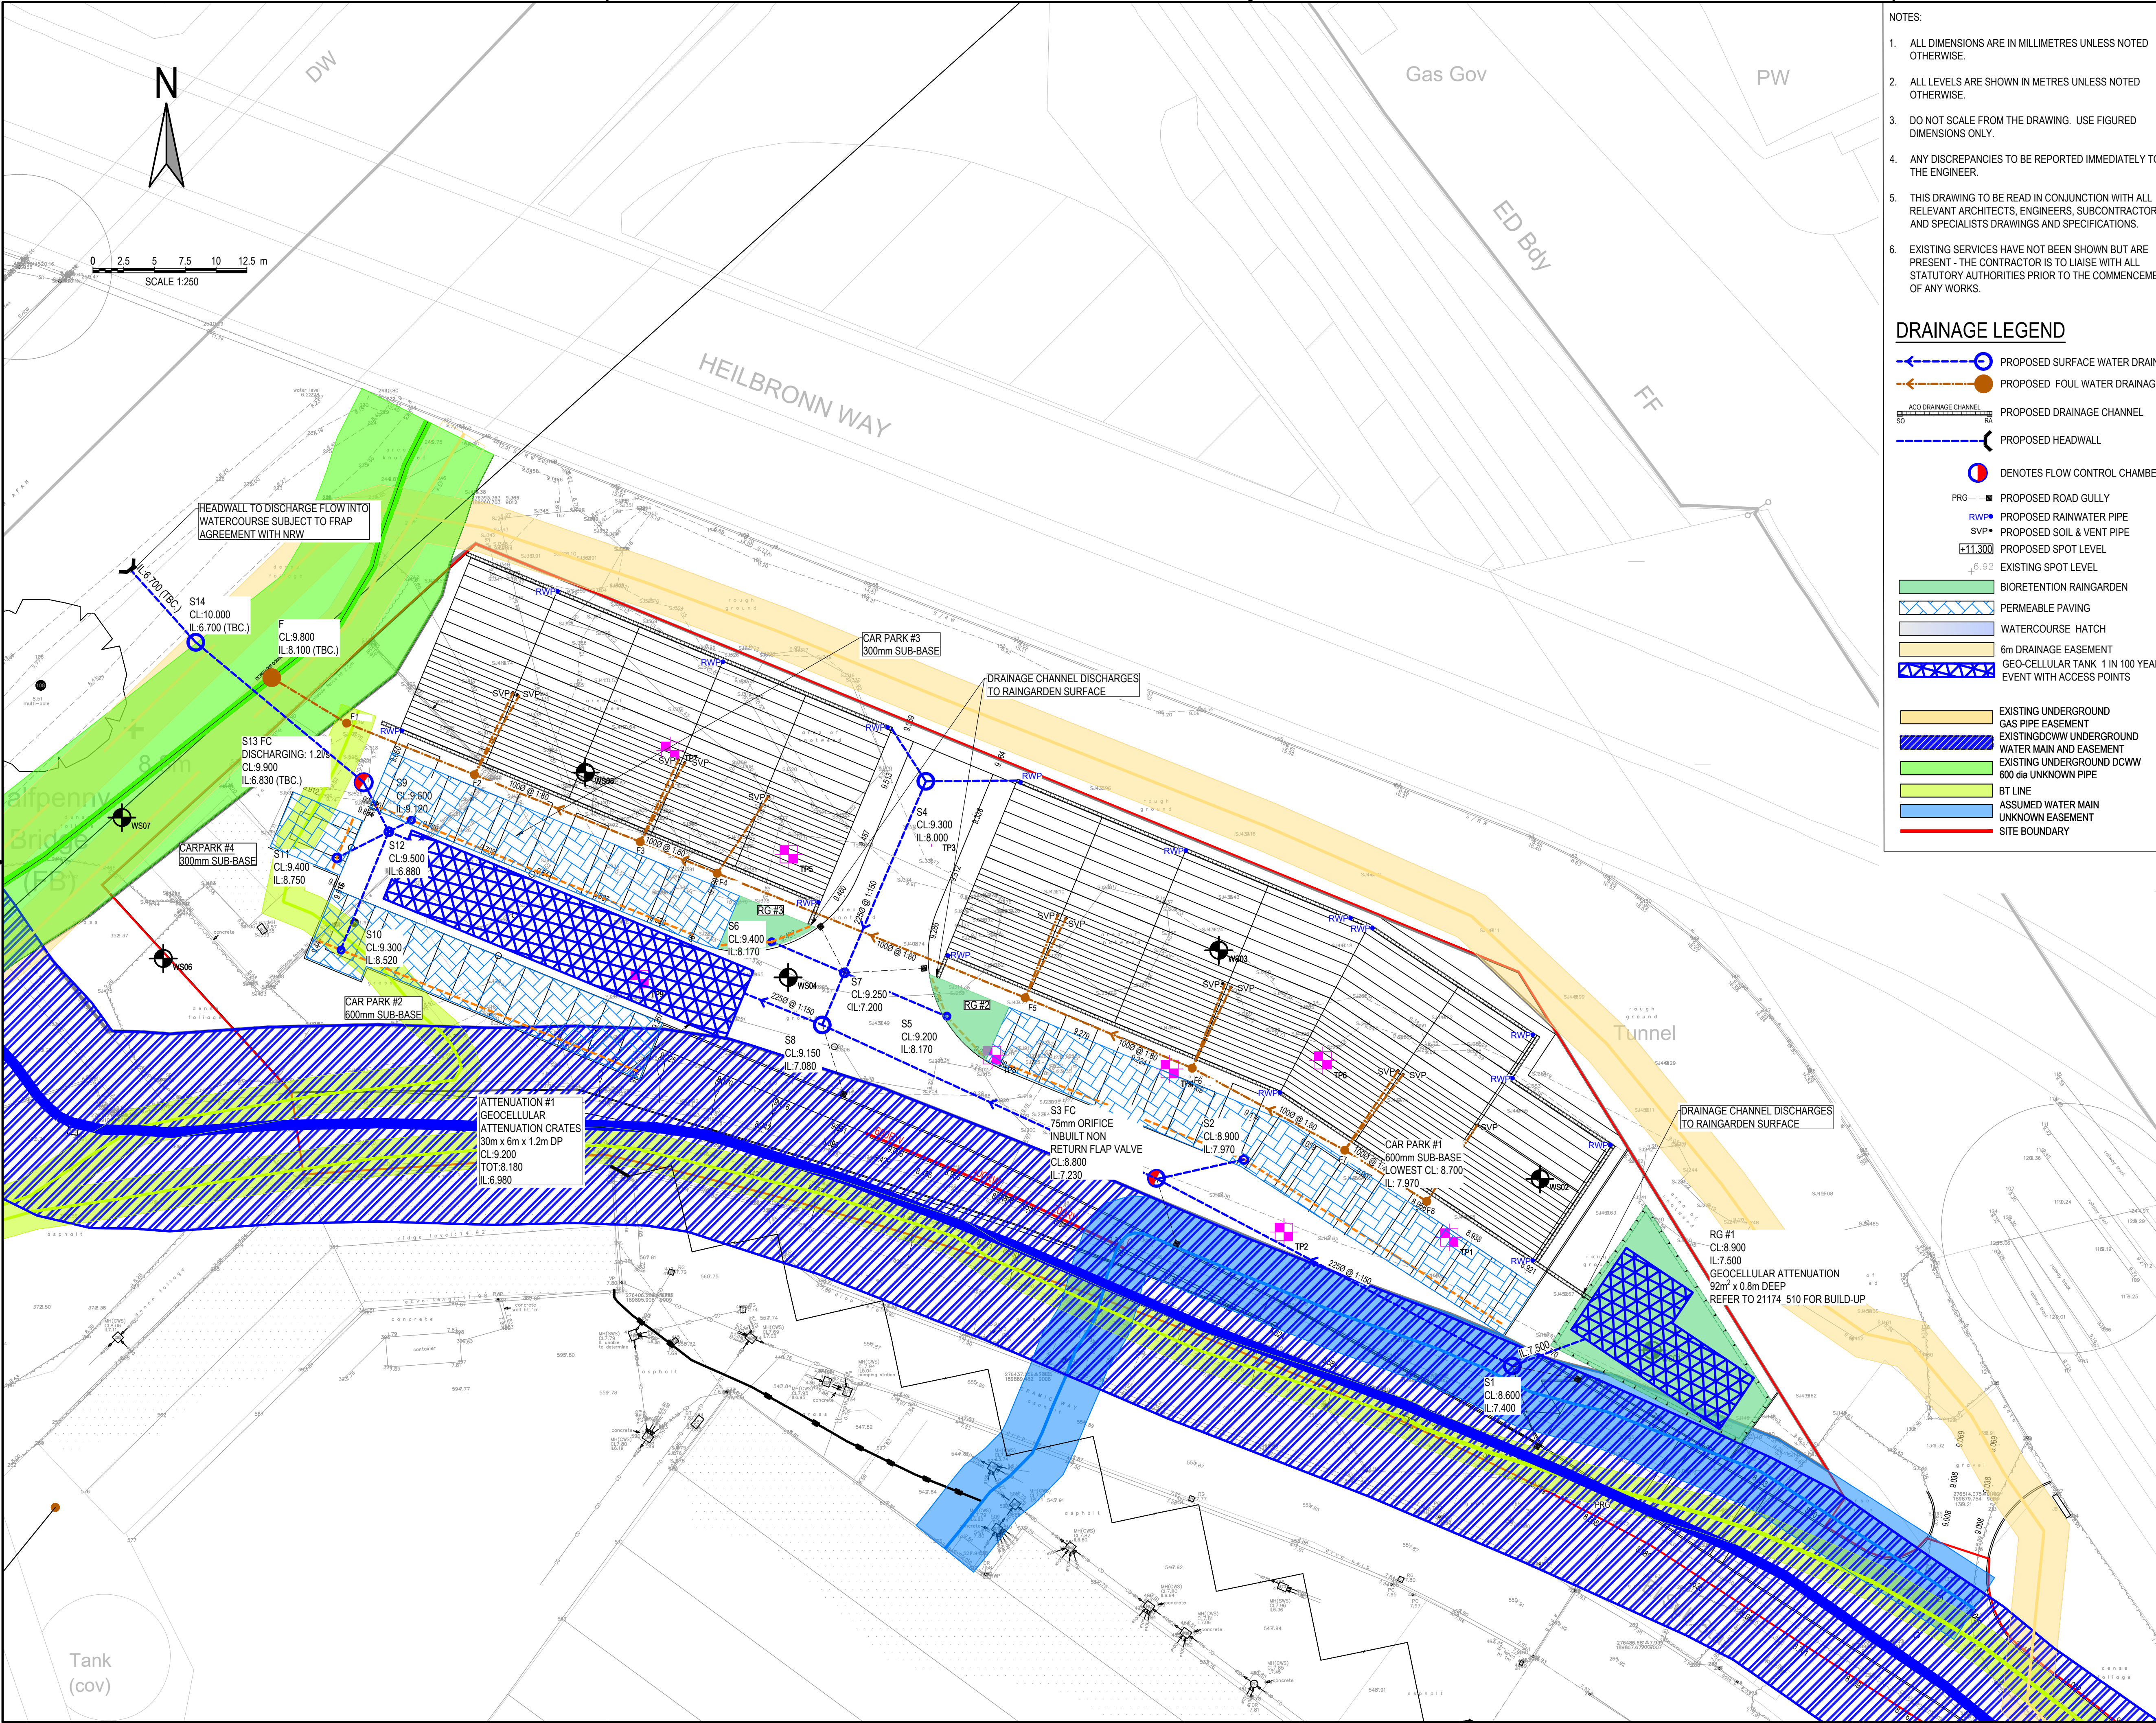

NOTES:

- ALL DIMENSIONS ARE IN MILLIMETRES UNLESS NOTED OTHERWISE.
- ALL LEVELS ARE SHOWN IN METRES UNLESS NOTED OTHERWISE.
- DO NOT SCALE FROM THE DRAWING. USE FIGURED DIMENSIONS ONLY.
- ANY DISCREPANCIES TO BE REPORTED IMMEDIATELY TO THE ENGINEER.
- THIS DRAWING TO BE READ IN CONJUNCTION WITH ALL RELEVANT ARCHITECTS, ENGINEERS, SUBCONTRACTORS AND SPECIALISTS DRAWINGS AND SPECIFICATIONS.
- EXISTING SERVICES HAVE NOT BEEN SHOWN BUT ARE PRESENT - THE CONTRACTOR IS TO LIAISE WITH ALL STATUTORY AUTHORITIES PRIOR TO THE COMMENCEMENT OF ANY WORKS.

DRAINAGE LEGEND

- PROPOSED SURFACE WATER DRAINAGE
- PROPOSED FOUL WATER DRAINAGE
- PROPOSED DRAINAGE CHANNEL
- PROPOSED HEADWALL
- DENOTES FLOW CONTROL CHAMBER
- PROPOSED ROAD GULLY
- PROPOSED RAINWATER PIPE
- PROPOSED SOIL & VENT PIPE
- PROPOSED SPOT LEVEL
- EXISTING SPOT LEVEL
- BIORETENTION RAINGARDEN
- PERMEABLE PAVING
- WATERCOURSE HATCH
- 6m DRAINAGE EASEMENT
- GEO-CELLULAR TANK 1 IN 100 YEAR EVENT WITH ACCESS POINTS
- EXISTING UNDERGROUND GAS PIPE EASEMENT
- EXISTING DCWW UNDERGROUND WATER MAIN AND EASEMENT
- EXISTING UNDERGROUND DCWW 600 dia UNKNOWN PIPE
- BT LINE
- ASSUMED WATER MAIN
- UNKNOWN EASEMENT
- SITE BOUNDARY

GENERAL DRAINAGE NOTES:

- MH COVERS AND FRAMES TO CONFORM TO BS EN 124:
 - D400 - SUITABLE FOR CARRIAGEWAYS, HARD SHOULDERS AND PARKING AREAS FOR ALL TYPES OF FAST MOVING VEHICLES
 - B125 - SUITABLE FOR AREAS WHERE SLOW MOVING DELIVERY VANS AND PUBLIC VEHICLES MAY HAVE ACCESS
 - A15 - SUITABLE FOR AREAS WHICH CAN ONLY BE USED BY PEDESTRIANS AND PEDAL CYCLISTS
- TYPE S BEDDING AND SURROUND TO ALL PIPES EXCEPT IN THE FOLLOWING CIRCUMSTANCES, IN WHICH TYPE Z BEDDING AND SURROUND ARE TO BE USED:
 - DOMESTIC GARDENS AND PATHWAYS WITHOUT ANY POSSIBILITY OF VEHICULAR ACCESS, 0.35m;
 - DOMESTIC DRIVEWAYS, PARKING AREAS AND YARDS WITH HEIGHT RESTRICTIONS TO PREVENT ENTRY BY VEHICLES WITH A GROSS VEHICLE WEIGHT IN EXCESS OF 7.5 TONNES, 0.5m;
 - DOMESTIC DRIVEWAYS, PARKING AREAS AND NARROW STREETS WITHOUT FOOTWAYS (E.G. MEWS DEVELOPMENT) WITH LIMITED ACCESS FOR VEHICLES WITH A GROSS VEHICLE WEIGHT IN EXCESS OF 7.5 TONNES, 0.9m;
 - AGRICULTURAL LAND AND PUBLIC OPEN SPACE, 0.9m;
 - HIGHWAYS AND PARKING AREAS WITH UNRESTRICTED ACCESS TO VEHICLES WITH A GROSS VEHICLE WEIGHT IN EXCESS OF 7.5 TONNES, 1.2m.
- ALL EXISTING MANHOLE INVERTS TO BE CHECKED AND REPORTED TO THE ENGINEER PRIOR TO THE COMMENCEMENT OF DRAINAGE WORKS. EXISTING PIPE CONNECTIONS ARE TO BE CCTV SURVEYED AND INSPECTED BY THE ENGINEER AND LOCAL AUTHORITY. IF THE PIPE CONNECTION IS FOUND TO BE DAMAGED OR IN DISTRESS, THE CONTRACTOR IS TO CARRY OUT REMEDIAL WORKS OR PROVIDE A NEW CONNECTION TO THE EXISTING SEWER (PIPE SIZE AND GRADIENT TO BE DETERMINED BY THE ENGINEER).
- THE GRADIENTS INDICATED AGAINST THE DRAIN RUNS ARE APPROXIMATE ONLY. THE CONTRACTOR SHALL INSTALL DRAINS TO THE INVERT LEVELS SHOWN FOR EACH MANHOLE OR OTHER INDICATED POSITION.
- ALL PLOT FOUL DRAINAGE TO BE MINIMUM 100mm DIAMETER UNLESS OTHERWISE NOTED.
- ALL JOINTING IN ACCORDANCE WITH MANUFACTURERS TECHNICAL ADVICE & SPECIFICATION.
- ALL NON ADOPTABLE DRAINAGE TO BE THE STANDARD UPVC 110mm, 160mm DRAINAGE AND MANUFACTURED TO BS-EN 1401 AND BS 4660 UNLESS NOTED OTHERWISE.
- ALL STORM WATER DRAINAGE TO BE A MINIMUM OF 150mm DIAMETER UNLESS OTHERWISE NOTED.
- SOIL & VENT PIPE LOCATION AND NUMBER TO BE CONFIRMED WITH ARCHITECT.
- THIS DRAWING TO BE READ IN CONJUNCTION WITH ALL RELEVANT ENGINEERS DRAWINGS, TOGETHER WITH THEIR LATEST SPECIFICATIONS. ANY DISCREPANCIES ARE TO BE REPORTED TO THE ENGINEER (VALE CONSULTANCY) AS SOON AS POSSIBLE.
- FIGURED DIMENSIONS ONLY TO BE USED. ANY QUERIES OR DISCREPANCIES TO BE REFERRED TO THE ENGINEER (VALE CONSULTANCY) IMMEDIATELY.
- TEMPORARY WORKS DESIGN BY OTHERS.
- DESIGN RISK ASSESSMENTS AND METHOD STATEMENTS ARE TO BE PROVIDED TO THE PRINCIPLE CONTRACTOR PRIOR TO THE COMMENCEMENT OF ANY WORKS.

rev.	drawn	chd.	HT	PG	date	description
02	PN	HT	PG	03.02.26		SITE LAYOUT UPDATES
01	PN	HT	PG	28.01.26		FIRST ISSUE

Client
LIFE PROPERTY GROUP LTD

Project
CRAMIC WAY
PORT TALBOT

Title
DRAINAGE LAYOUT

ValeConsultancy
CONSULTING CIVIL & STRUCTURAL ENGINEERS
29 Bocan Park, Old Field Road, Pencoed, Bridgend CF35 5LJ.
Phone: 01656 863794 Email: enquiries@vale-consultancy.co.uk

date	drawn	checked		approved	
28.01.26	PN	HT	28.01.26	PG	28.01.26
scale @ A1		project no.			
1:250		21174			

status	drg. no.	rev.
P	21174_500	02