
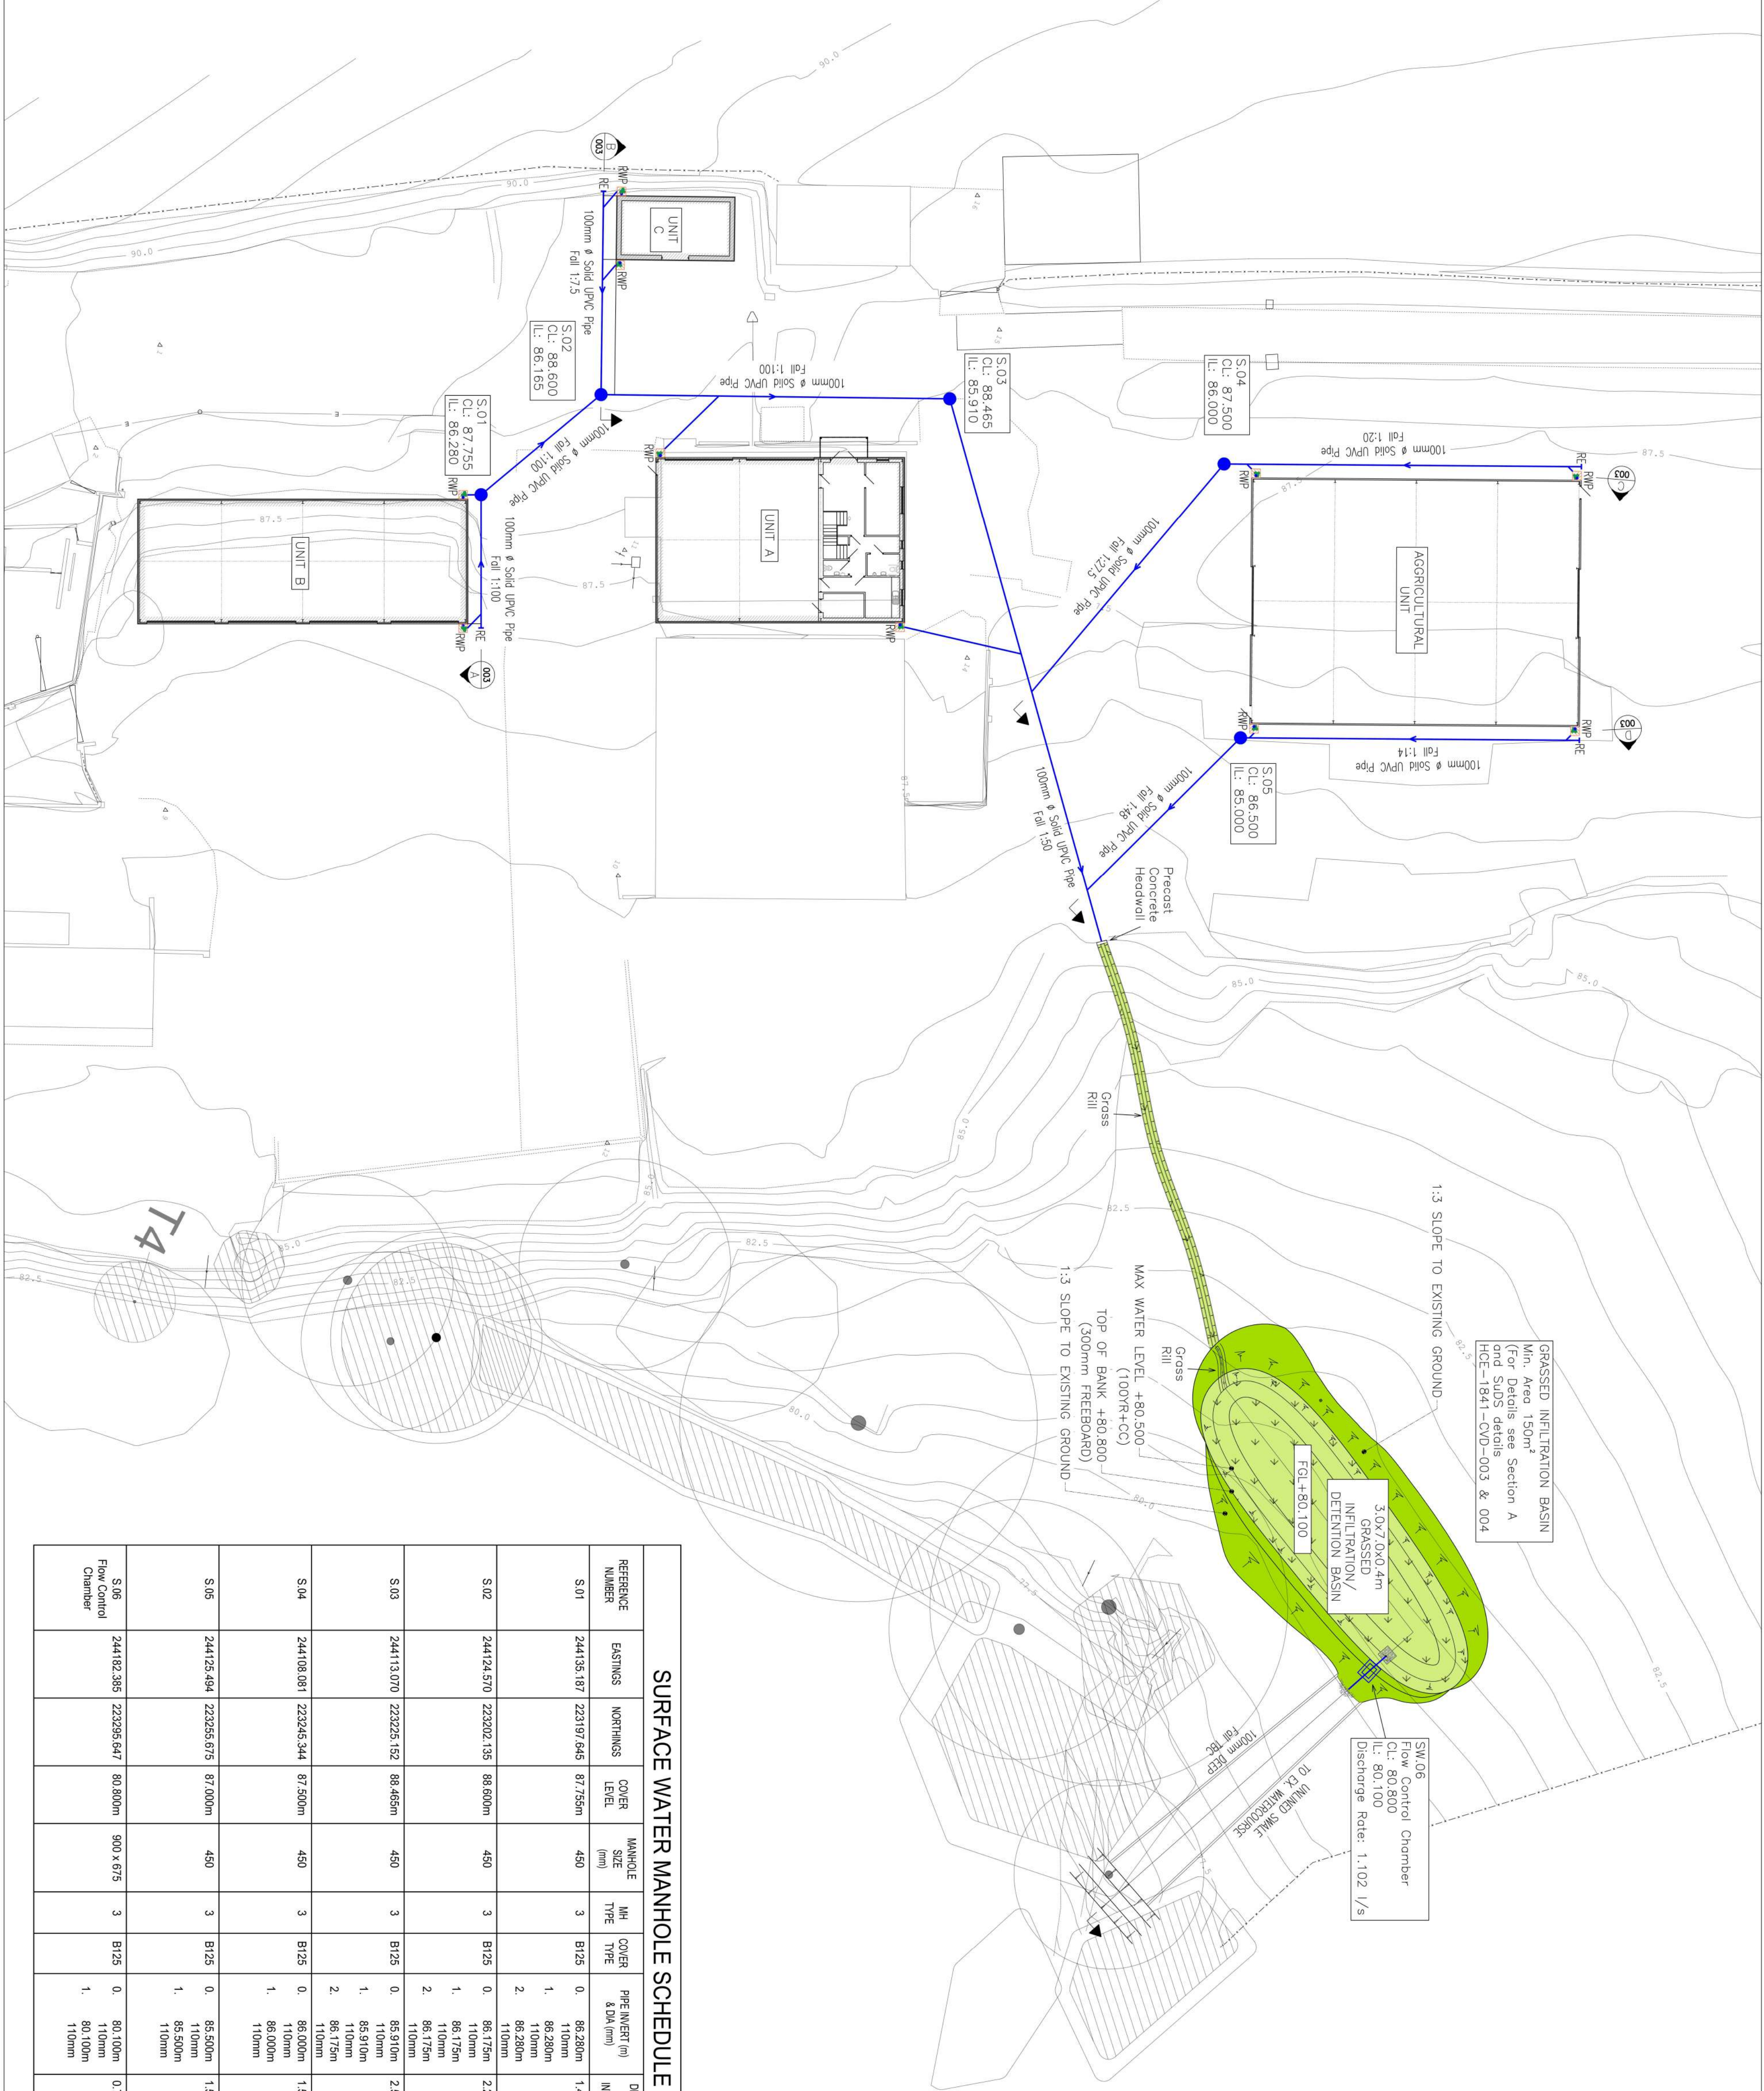


DO NOT SCALE

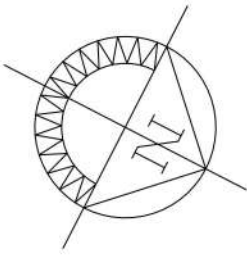

SURFACE WATER MANHOLE SCHEDULE									
REFERENCE NUMBER	EASTINGS	NORTHINGS	COVER LEVEL	MANHOLE SIZE (mm)	MH TYPE	COVER TYPE	PIPE (INVERT (m) & DIA (mm))	DEPTH TO INVERT	CONNECTIONS
S.01	244135.187	223191.645	87.755m	450	B125	0	86.280m 110mm	1.475m	0 1 2
S.02	244124.570	223202.135	88.600m	450	B125	0	86.175m 110mm	2.245m	0 1 2
S.03	244113.070	223225.152	88.465m	450	B125	0	85.910m 110mm	2.555m	0 1 2
S.04	244108.081	223245.544	87.500m	450	B125	0	86.000m 110mm	1.500m	1 0
S.05	244125.494	223255.675	87.000m	450	B125	0	85.500m 110mm	1.500m	1 0
S.06	244182.385	223295.647	80.800m	900 x 675	B125	0	80.100m 110mm	0.700m	1 0

- KEY
- PROPOSED SURFACE WATER DRAINAGE
 - RWP
 - RFP LOCATION
 - RE
 - RODDING EYE
 - HIGHWAY GULLY
 - SURFACE WATER MANHOLE
 - PROPOSED RAINWATER GARDEN
 - SUDS GRASSED AREA

- NOTES:
- STORM DRAINAGE DESIGN AND CONSTRUCTION TO BE IN ACCORDANCE WITH SEWERS FOR ADOPTION 7th EDITION AND THE REQUIREMENTS OF THE STATUTORY INSTRUMENTS.
 - CONTRACTORS WORKING ON LIVE SEWERS ARE TO BE SSP REGISTERED WITH THE RELEVANT ACCREDITATION.

- NOTES:
- RAINWATER GARDEN PLANTING LIST AND ON DRAWING No. 001.

REV	DATE	BY	DESCRIPTION	CHK	APPD
001	22.05.2024	SC	Issued for Comment		
DRAWING STATUS					

HCE

Engineering Excellence

HCE Limited

Canolfan Gorsion

Centres Drive

Millers Drive

Gorsion

SA4 4QN

Tel: 01792 805010

Email: info@hcelimited.com

Web: www.hcelimited.com

CLIENT: MR. ALSTAIR & MRS ANWEN BUTLER

ARCHITECT: DR DESIGN LTD.

PROJECT: MARCHOLWS, PENIEL
CARMARTHENSHIRE
SA32 7AA

TITLE: SURFACE WATER
DRAINAGE PLAN

SCALE @ A1:	CHECKED	RD	APPROVED	HI
1:250				
DRAWN BY: HCE-1841-C/D-002	DESIGN DRAWN	SC	DATE	MAY 2025

PROJECT NO:	1841	DESIGN NO:	CVD	DWG NO:	002	REV:	R01
-------------	------	------------	-----	---------	-----	------	-----